




6 MECHANICAL MUA-2 - SECTION E-E  
SCALE: 1/4"=1'-0"

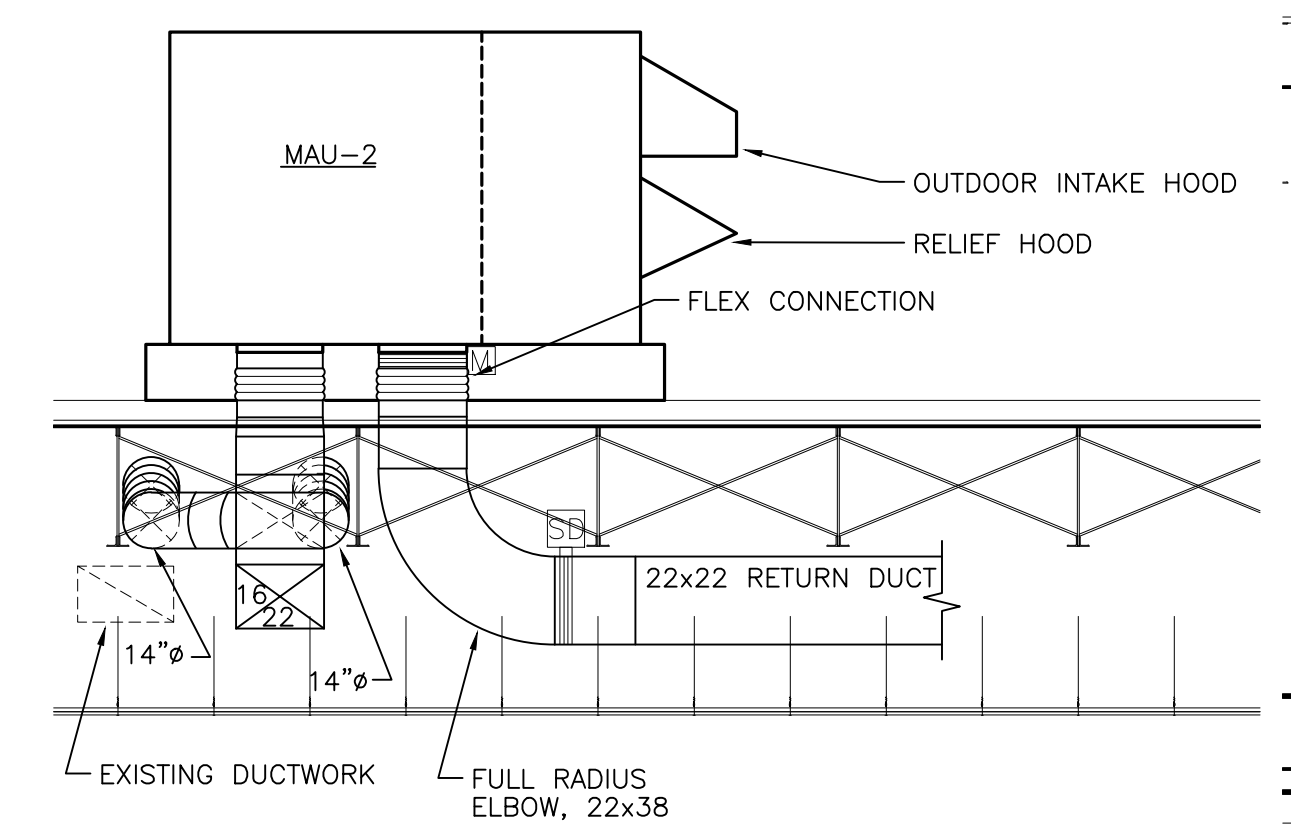


7 MECHANICAL MUA-2 SECTION F-F  
SCALE: 1/4"=1'-0"

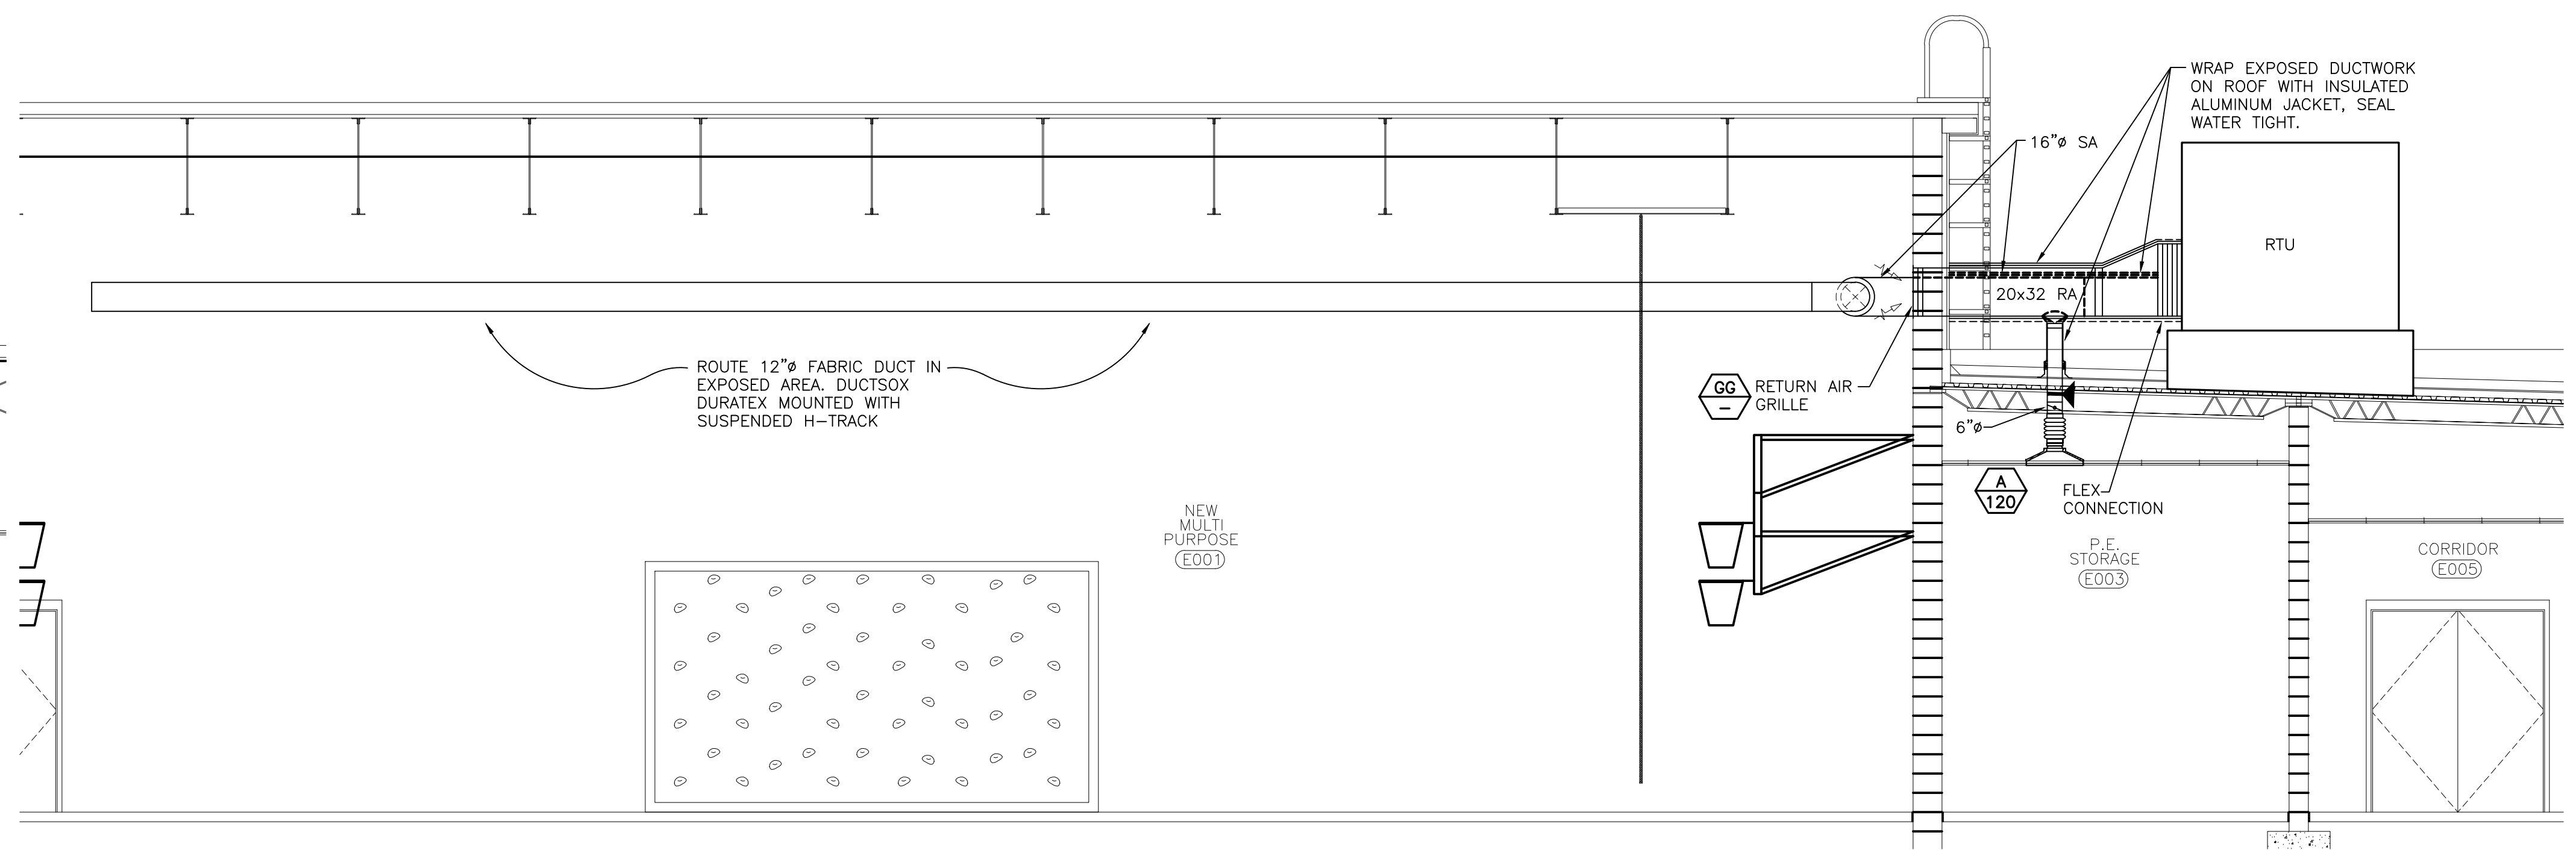

1 MECHANICAL MULTI-PURPOSE SECTION A-A  
SCALE: 1/4"=1'-0"

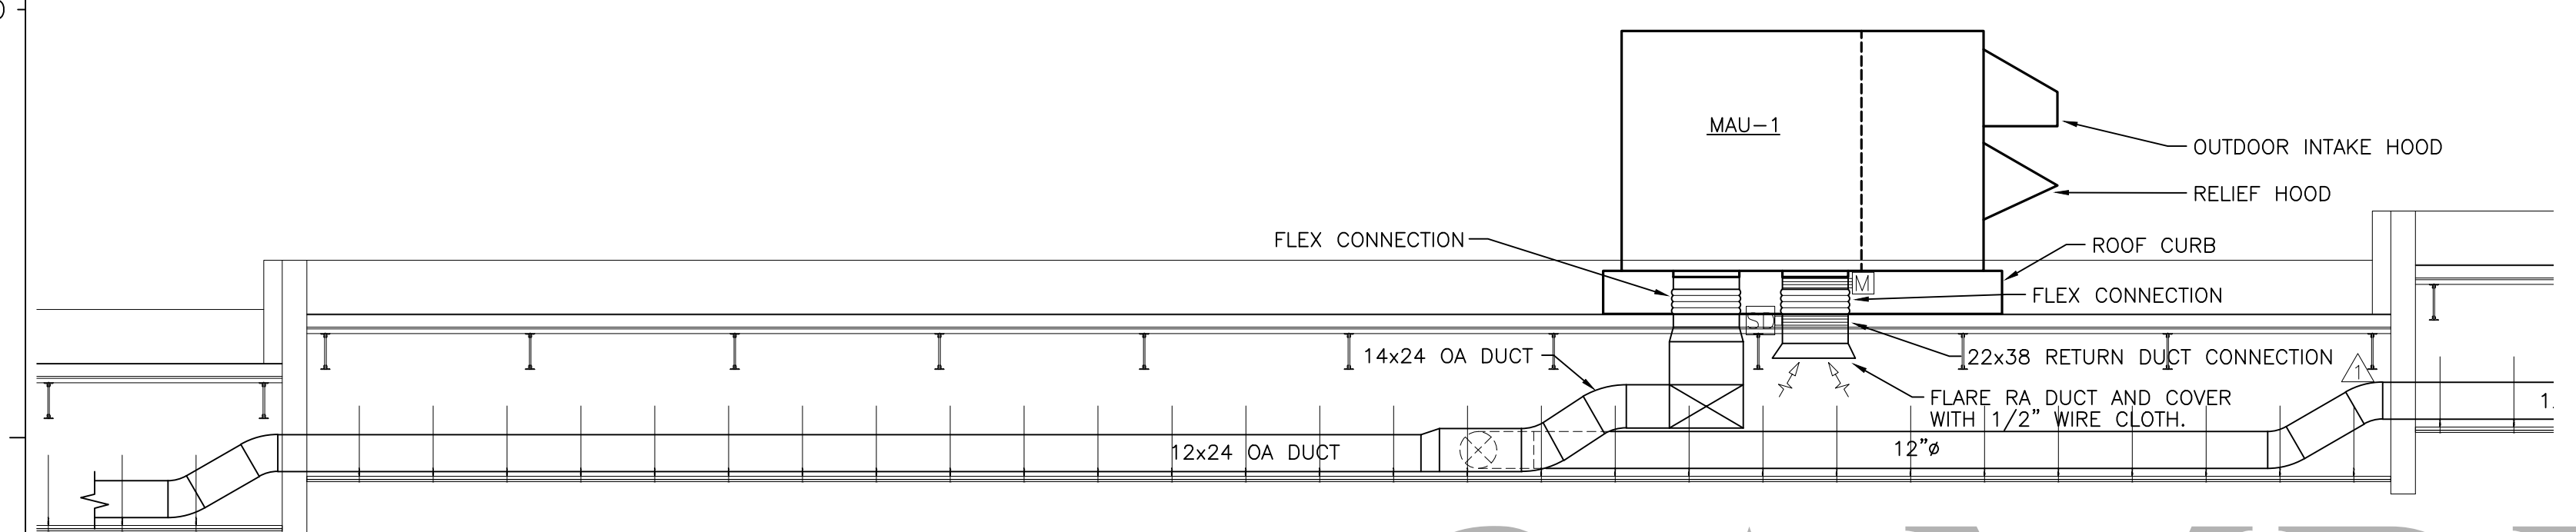


5 MECHANICAL CEILING SPACE PLAN - SECTION D-D  
SCALE: 1/4"=1'-0"

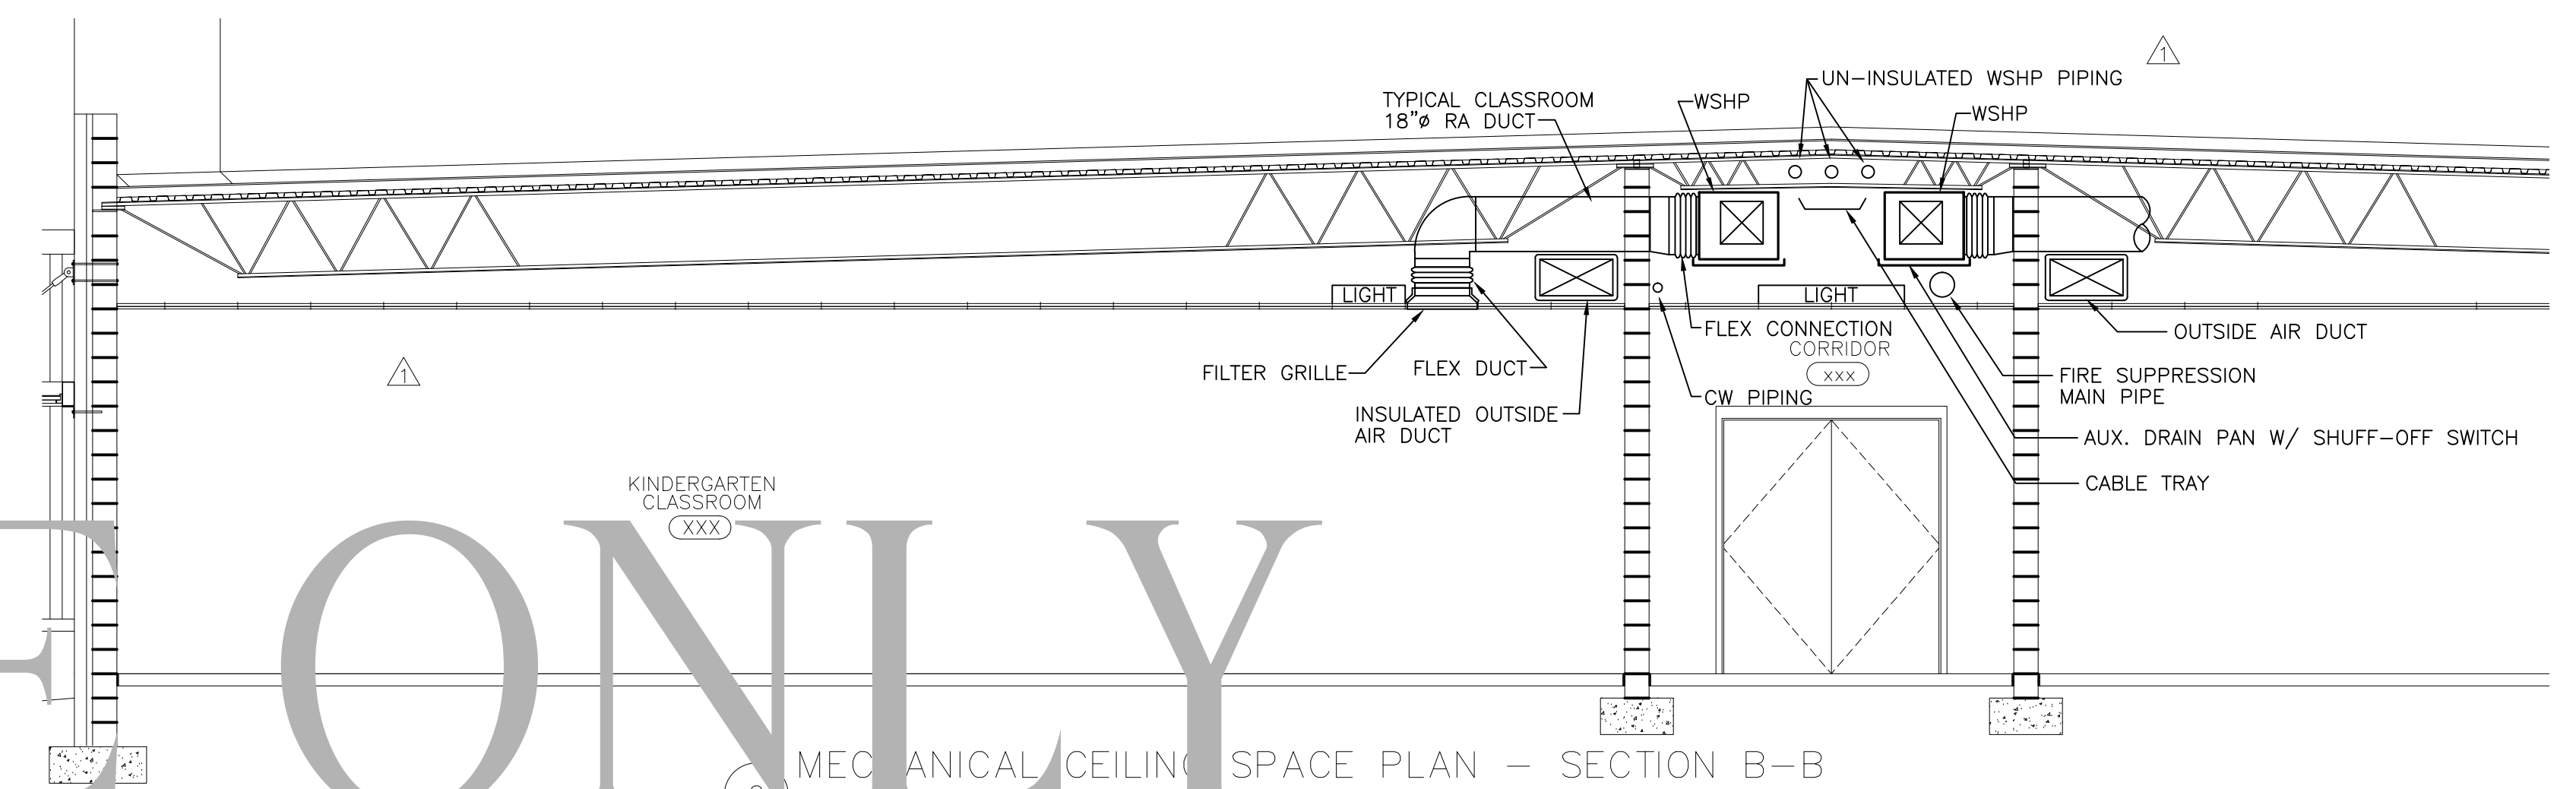


2 MECHANICAL CEILING SPACE PLAN - SECTION B-B  
SCALE: 1/4"=1'-0"

SAMPLE ONLY


COPYRIGHT BY  
CREATIVE CONCEPTS AND DESIGN, INC.

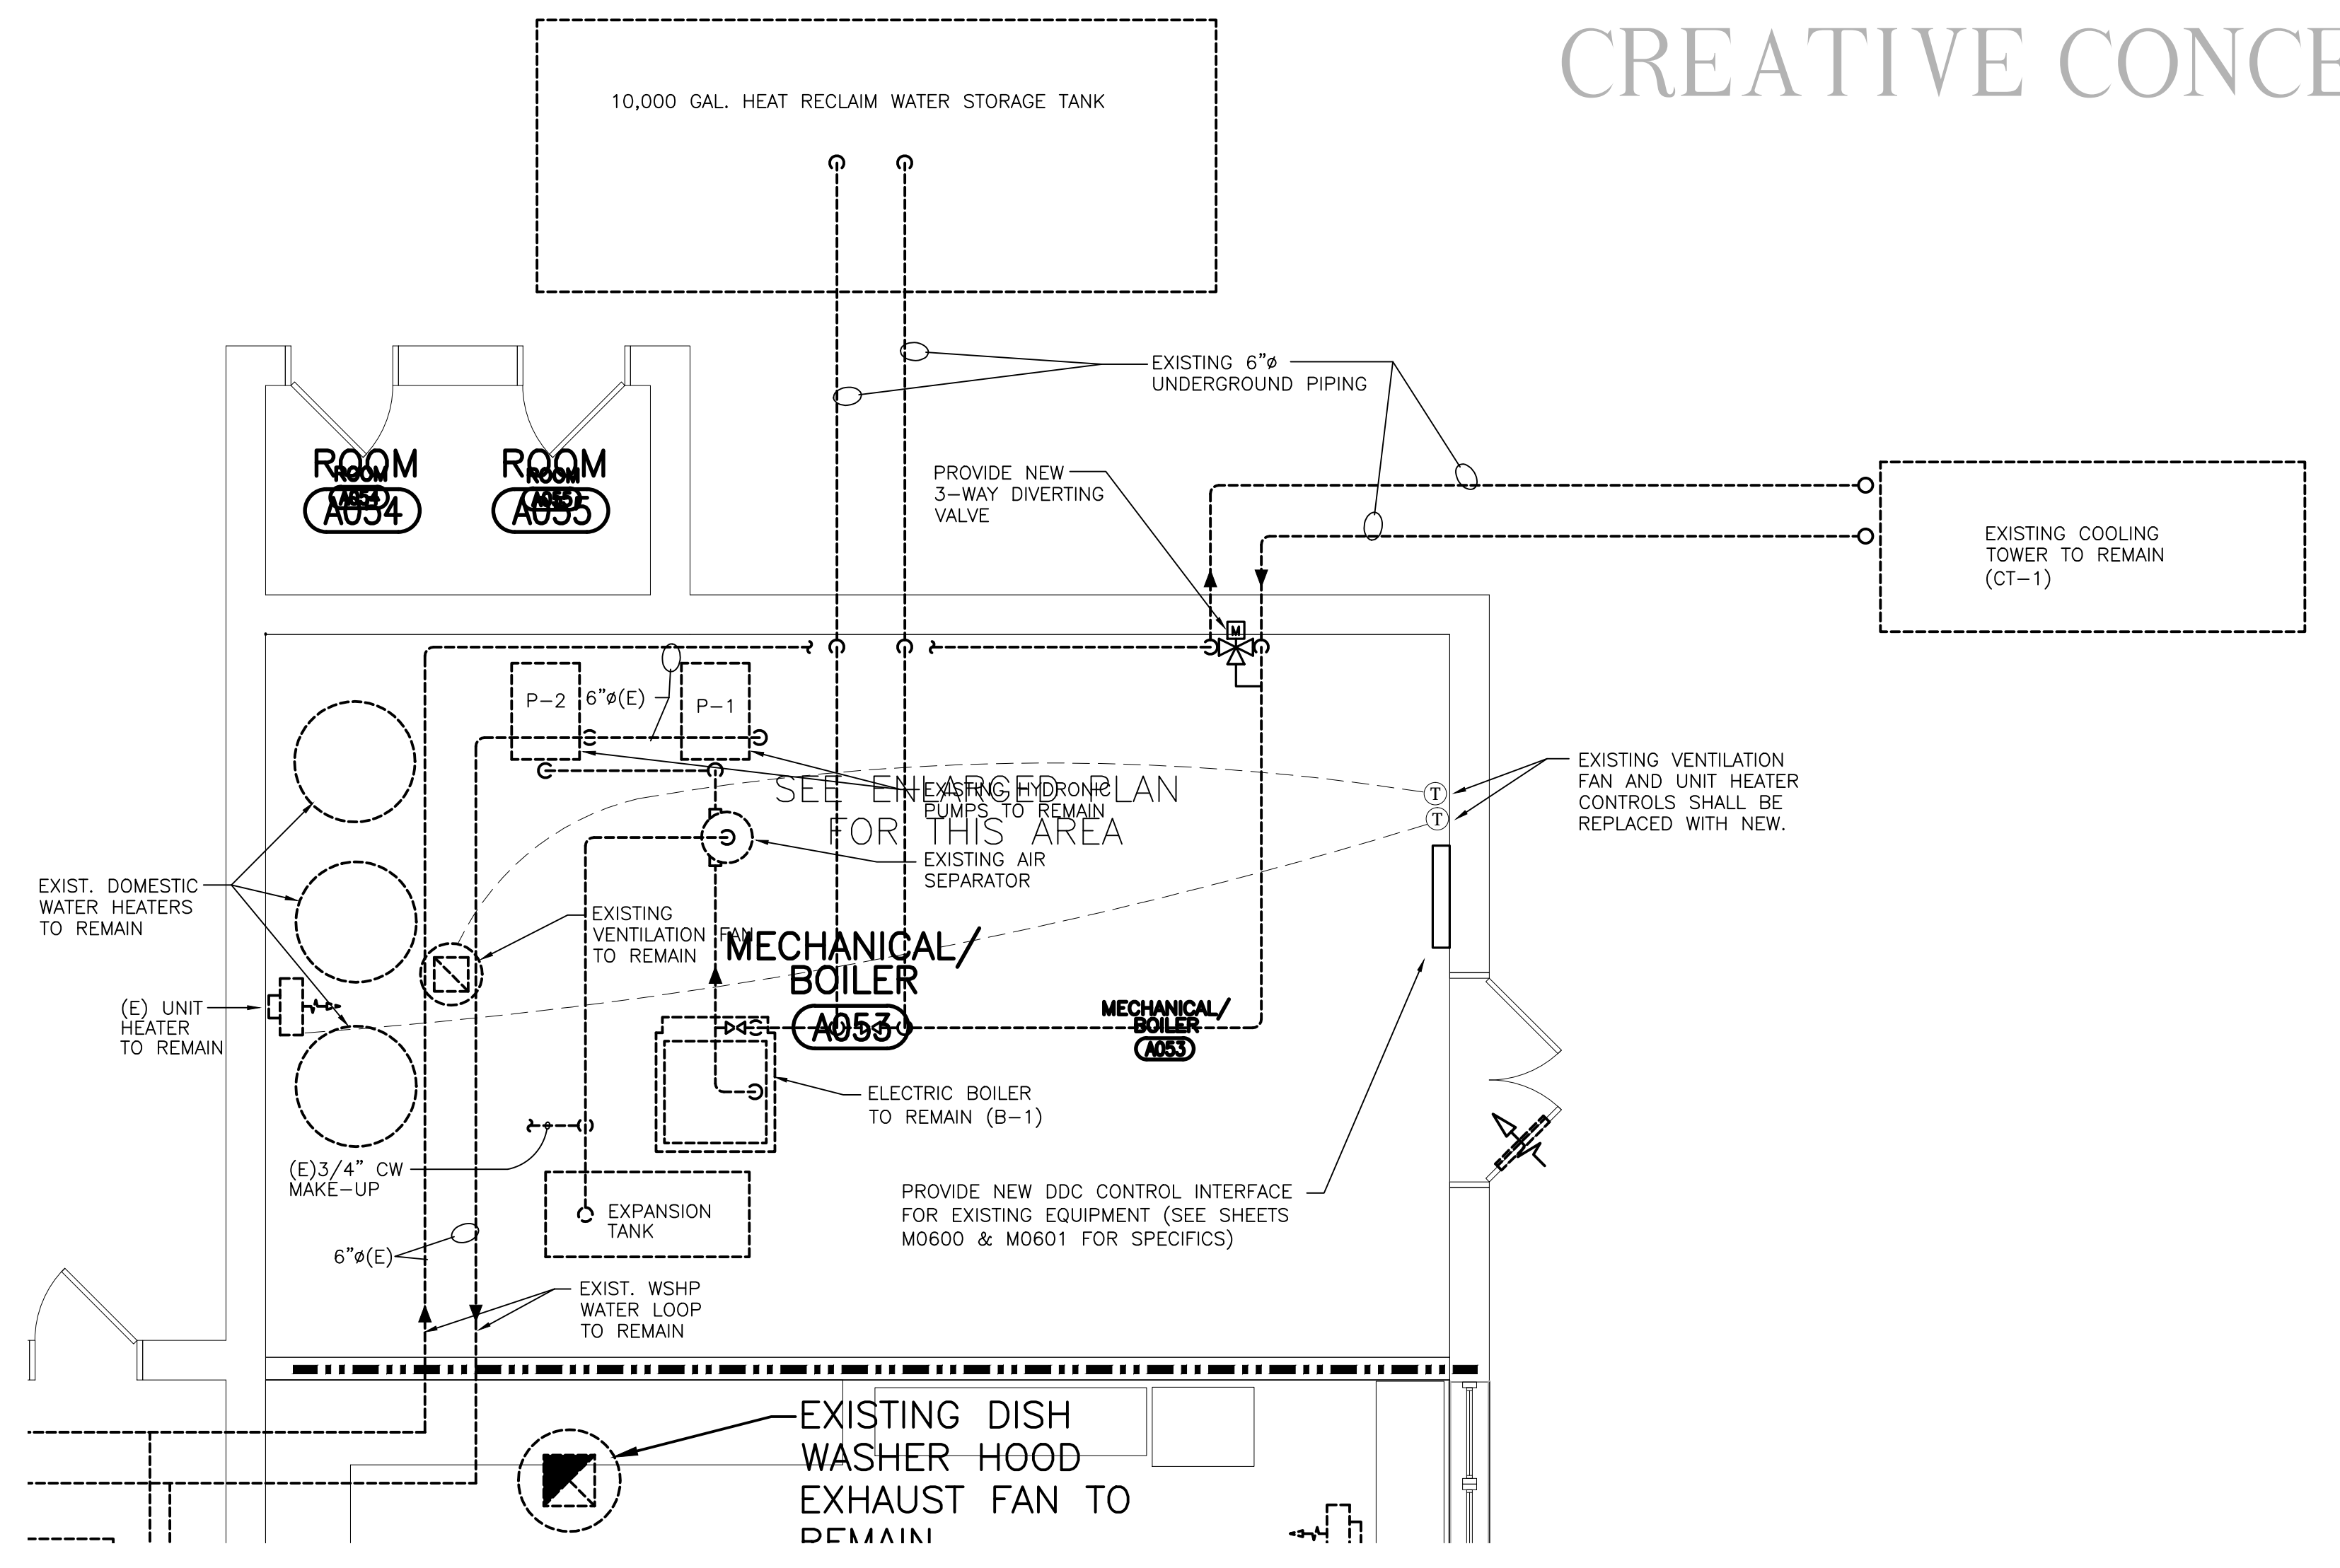

3 ENLARGED MECHANICAL PLAN  
SCALE: 1/4"=1'-0"

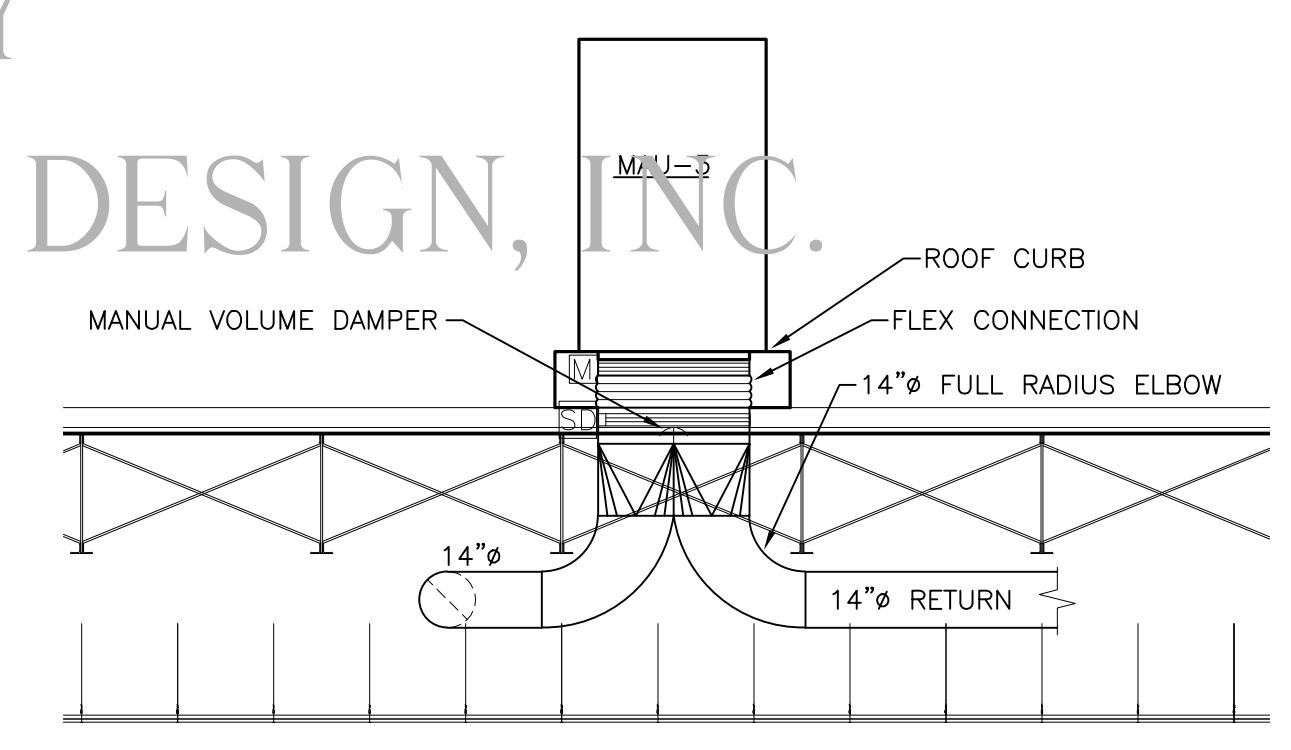

8 MECHANICAL MUA-3 SECTION G-G  
SCALE: 1/4"=1'-0"

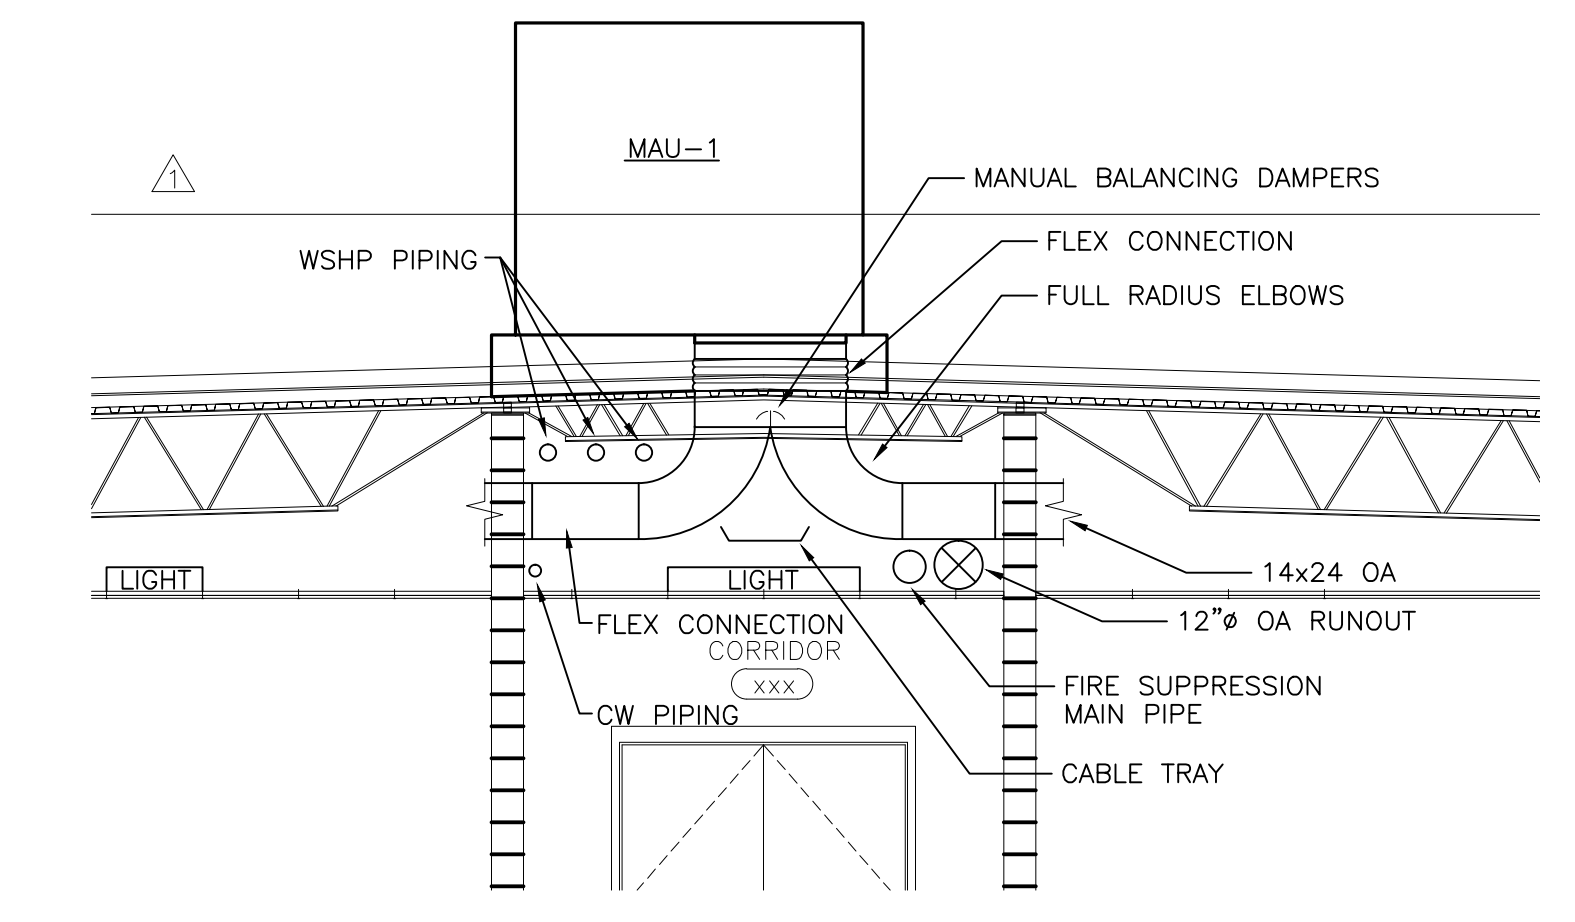


4 MECHANICAL MUA-1 - SECTION C-C  
SCALE: 1/4"=1'-0"

LEGEND	
	ONE-HOUR RATED WALL, EXTEND AND SEAL TO UNDERSIDE OF FLOOR OR ROOF DECK
	TWO-HOUR RATED WALL, EXTEND AND SEAL TO UNDERSIDE OF FLOOR OR ROOF DECK
	FOUR-HOUR RATED WALL, EXTEND AND SEAL TO UNDERSIDE OF FLOOR OR ROOF DECK

NOTES

KEYPLAN

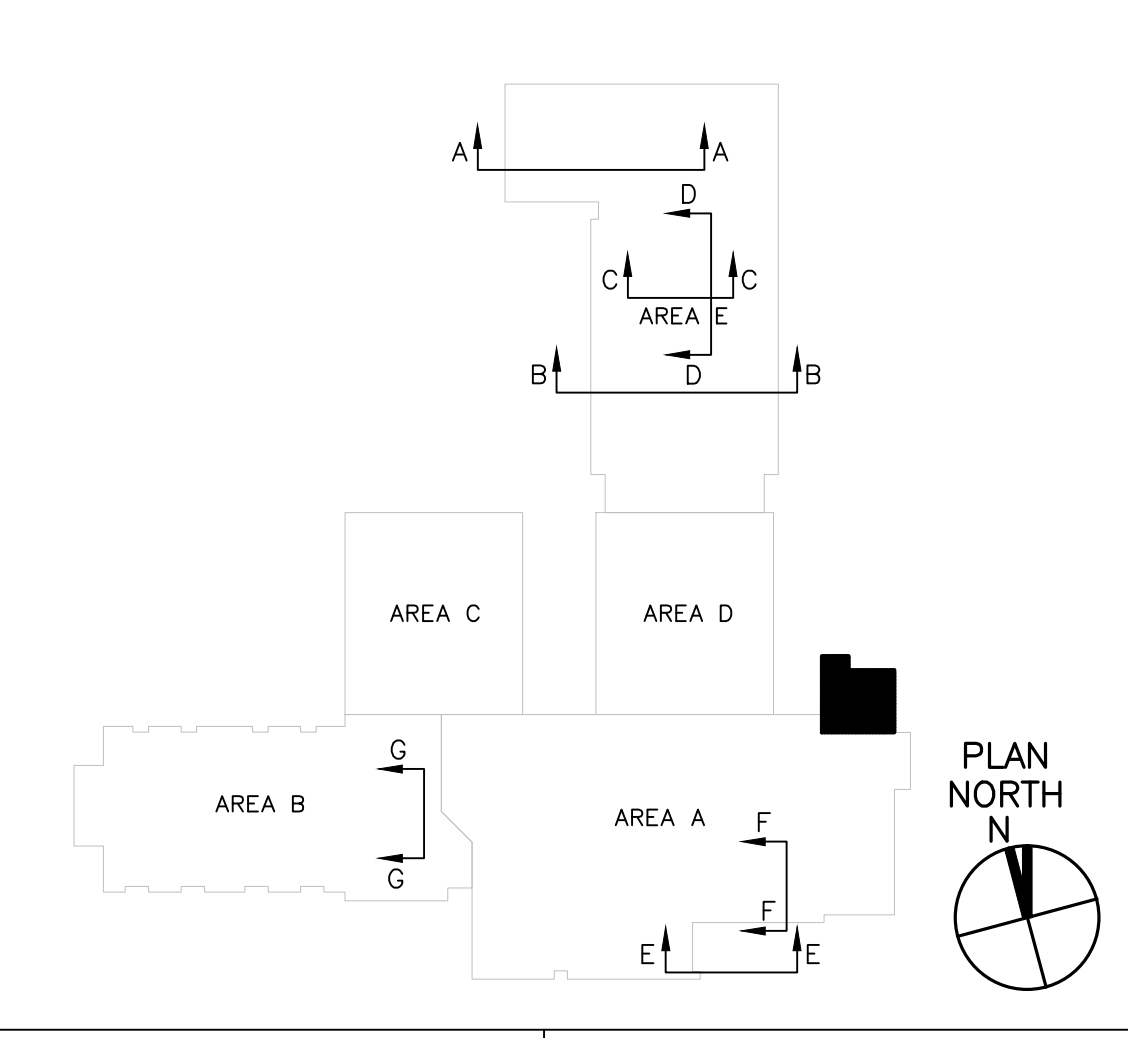

REVISIONS:  
1 BUILDING STANDARDS REVISIONS 6/16/06

PROJECT:  
DATE:  
DRAWN BY: WLK  
CHECKED BY: MBR

**RECORD DRAWING**  
DATE 10/18/2007

MECHANICAL ENLARGED PLANS & SECTIONS

**M0505**

SOLUTIONS THROUGH LISTENING  
SERVICE BY DESIGN