



SAMPLE ONLY

COPYRIGHT ©  
CREATIVE CONCEPTS AND DESIGN, INC.

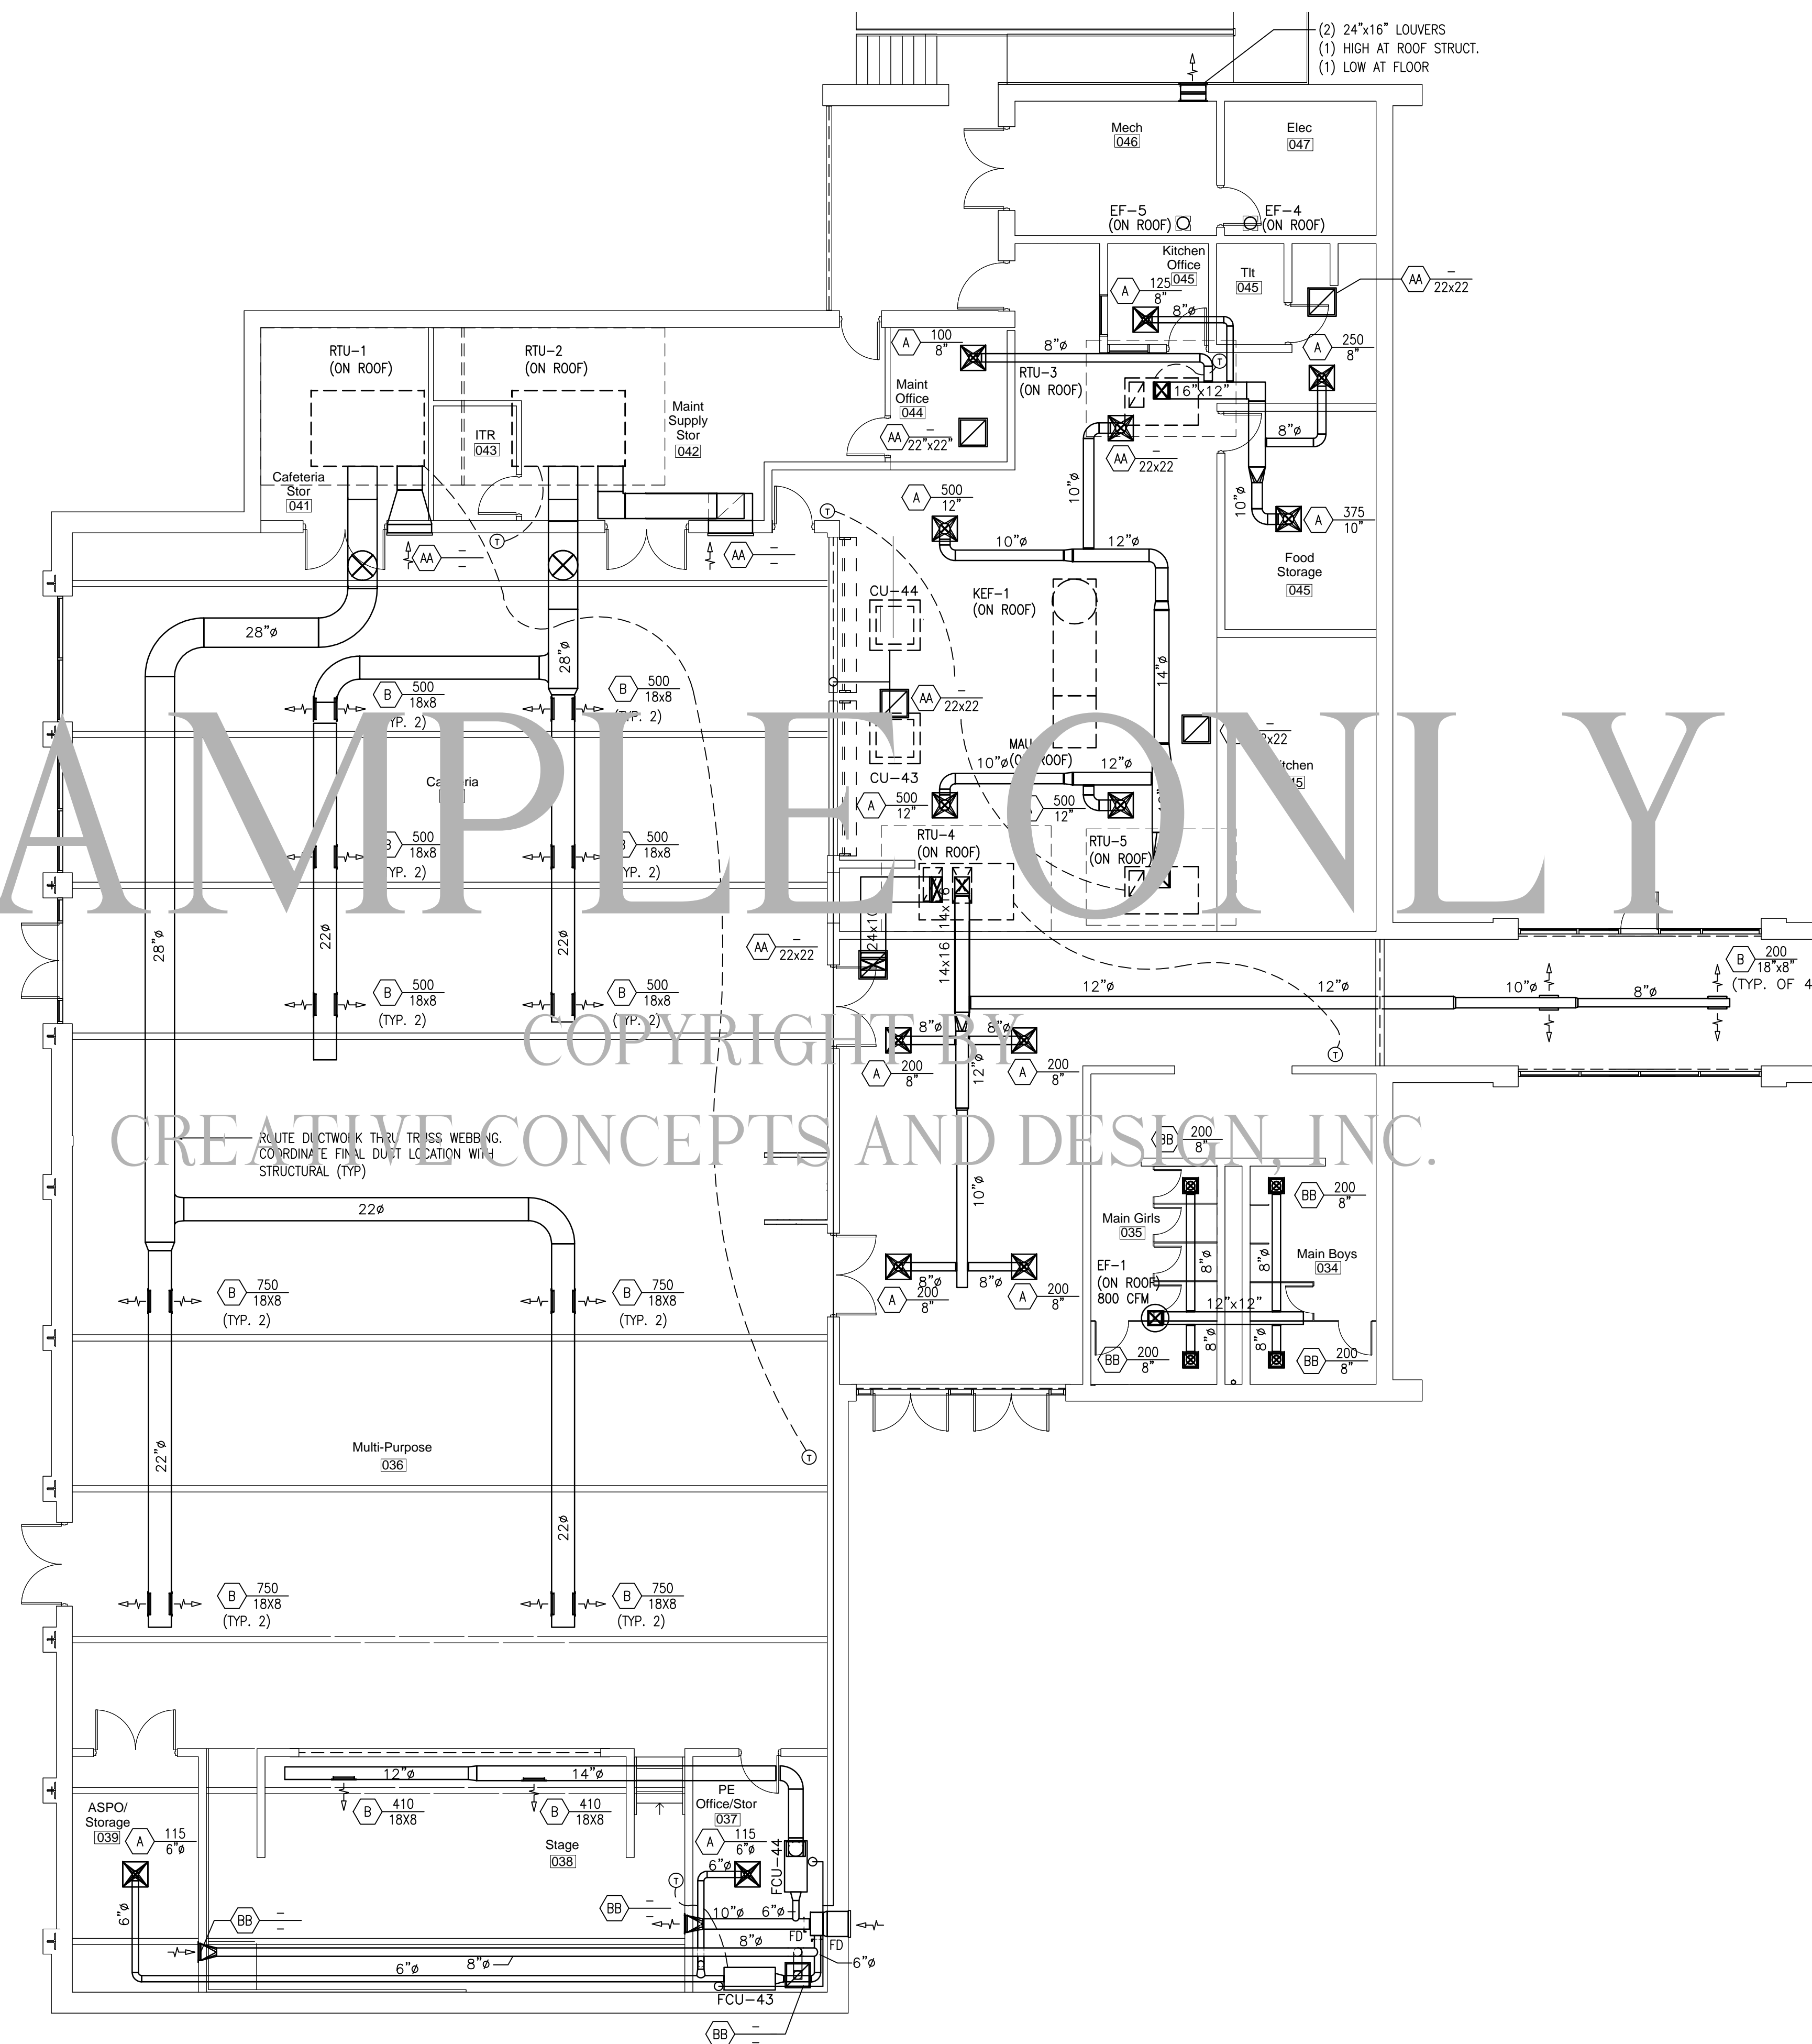

1 Enlarged Floor Plan Section A  
1/8" = 1'-0"

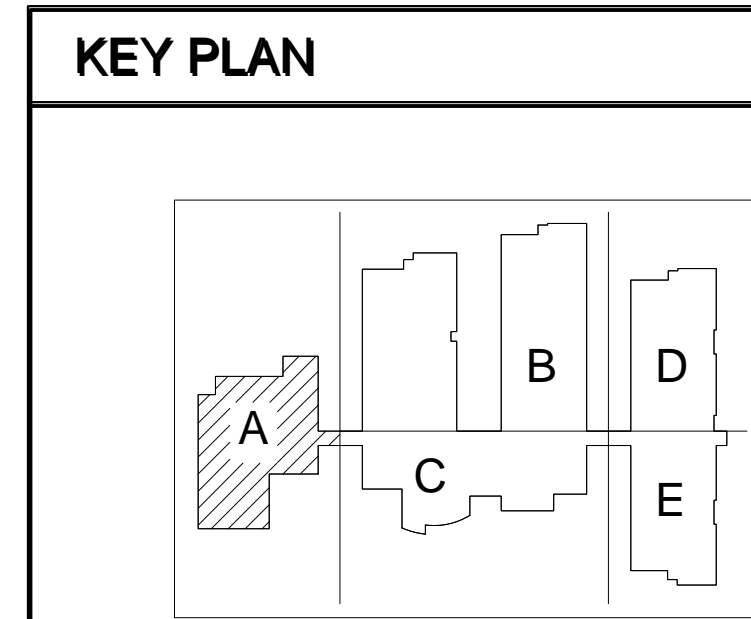

Elementary School

REV.	DESCRIPTION	DATE

SHEET TITLE	
ENLARGED HVAC PLAN SECTION A	
DRAWN BY:	CHECKED BY:
SB	
PROJ. NUMBER:	207035.00
ISSUE DATE:	08/19/08
DRAWING NO.	
<b>M2.01</b>	

