



SAMPLE ONLY

COPYRIGHT BY
CREATIVE CONCEPTS AND DESIGN, INC.

Elementary School

REV.	DESCRIPTION	DATE

1 Enlarged Floor Plan Section C
1/8" = 1'-0"

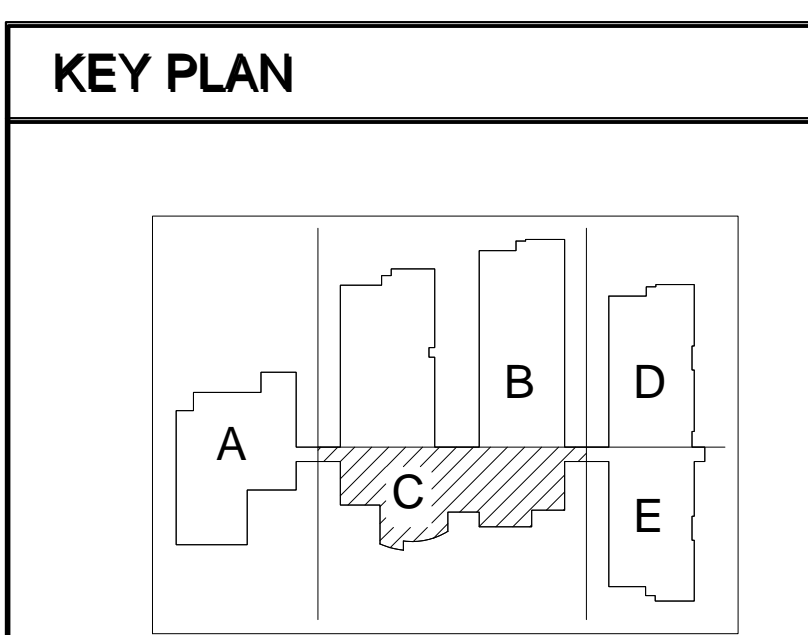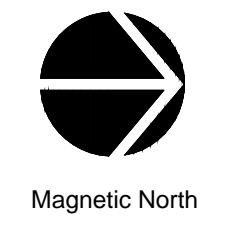

SHEET TITLE
**ENLARGED
HVAC PLAN
SECTION C**

DRAWN BY: SB	CHECKED BY:
PROJ. NUMBER: 207035.00	ISSUE DATE: 08/19/08
DRAWING NO.	

M2.03