


REV.	DESCRIPTION	DATE

SHEET TITLE	
PLUMBING SANITARY PLAN SECTION B	
DRAWN BY: SB	PROJ. MANAGER:
PROJ. NUMBER:	ISSUE DATE:
DRAWING NO.	

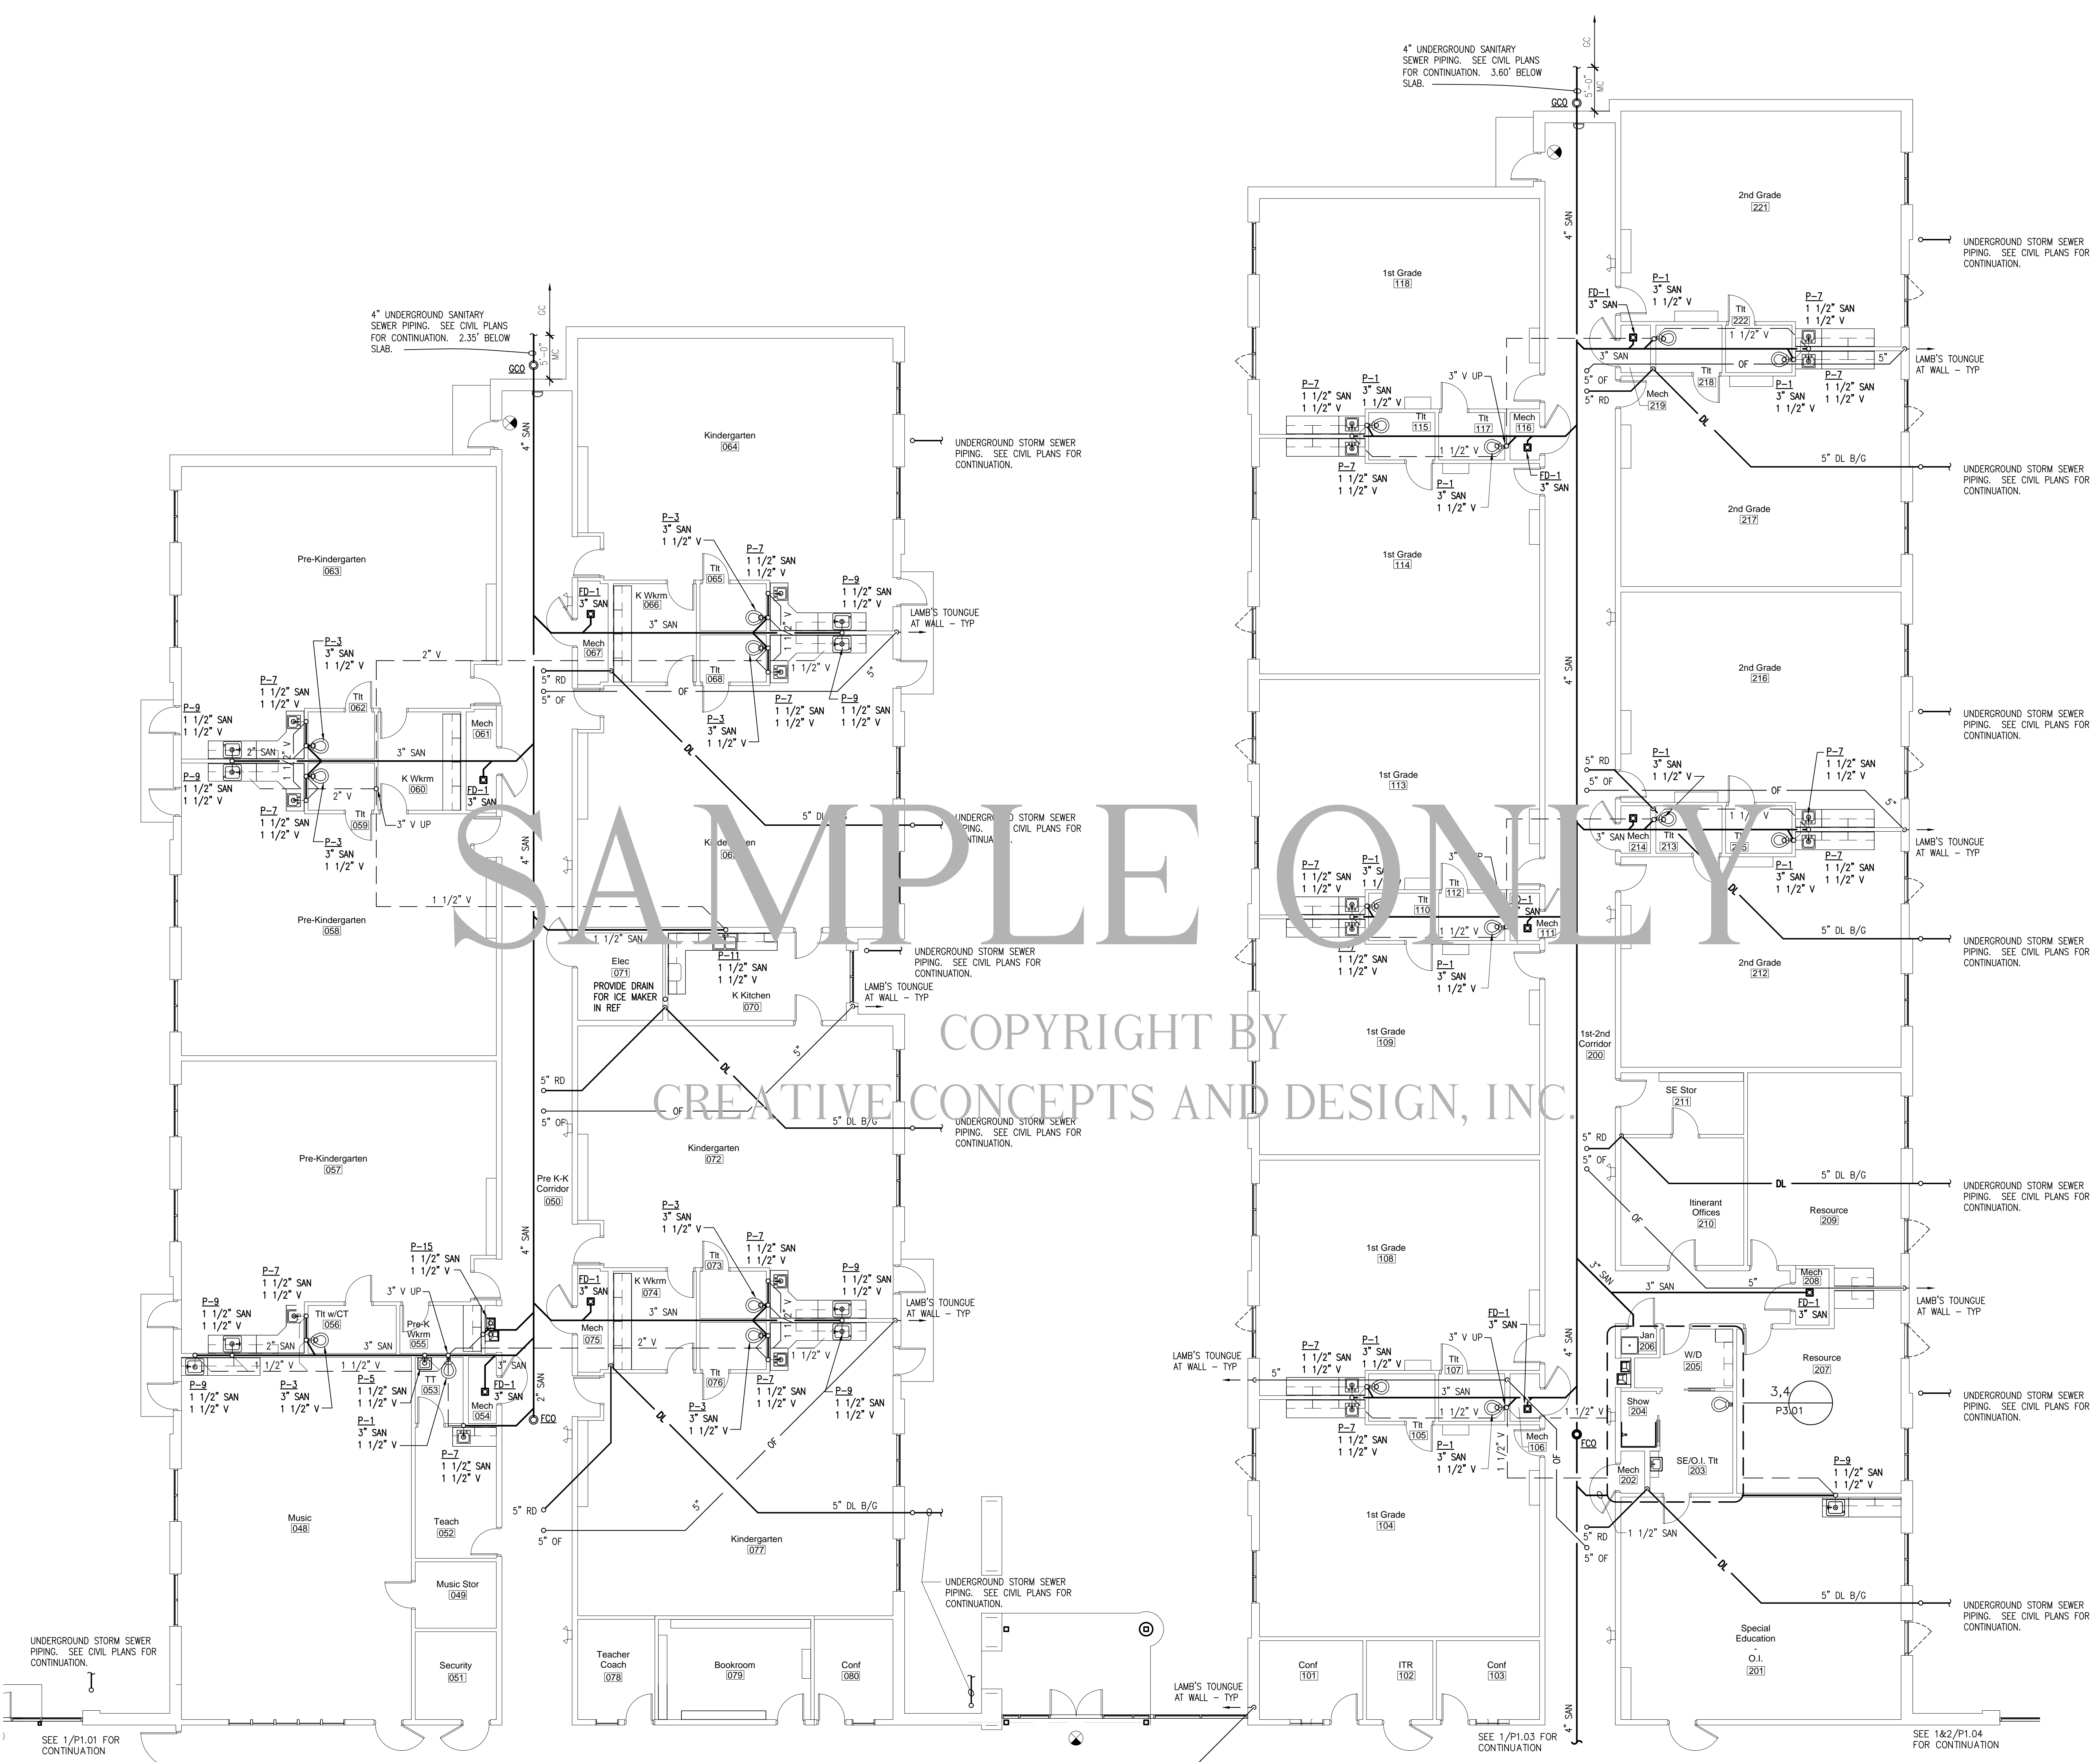

SAMPLE ONLY

COPYRIGHT BY
CREATIVE CONCEPTS AND DESIGN, INC

1 Plumbing Sanitary Plan Section B
1/8" = 1'-0"

