




1 ENLARGED 1ST FLOOR DOMESTIC WATER PLAN
 1/4" = 1'-0"

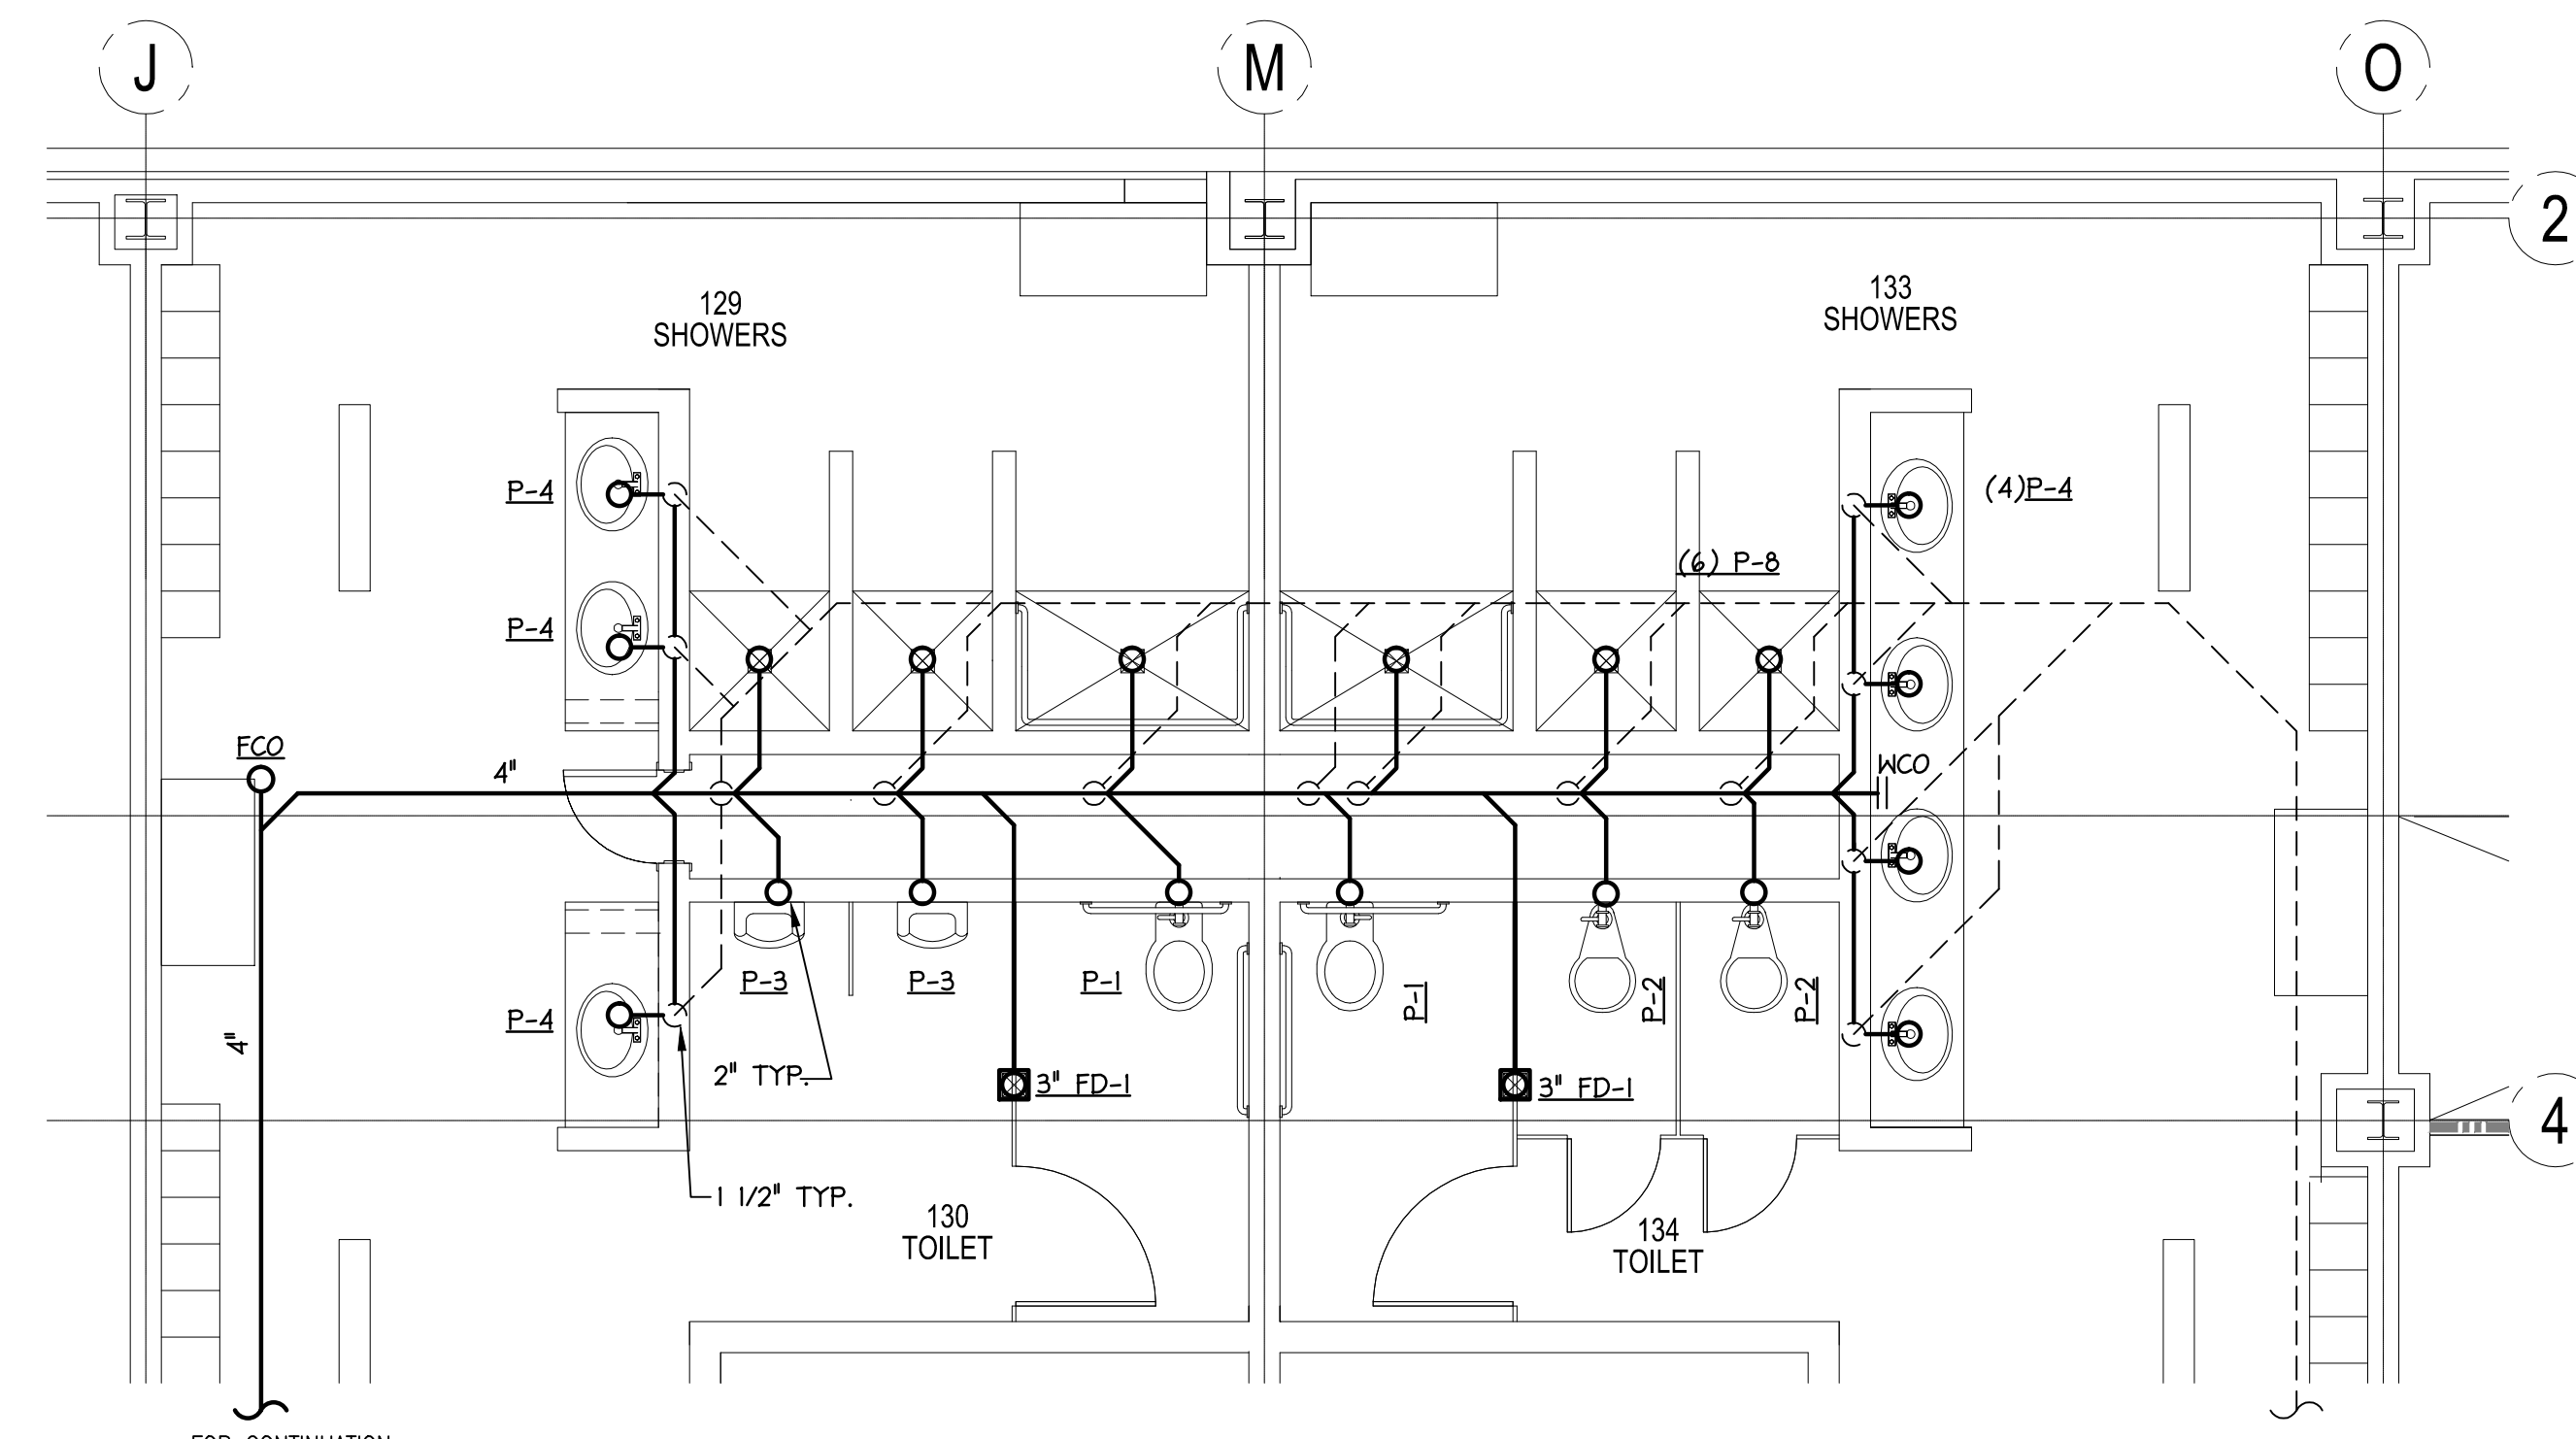


2 ENLARGED 1ST FLOOR SANITARY PLAN
 1/4" = 1'-0"

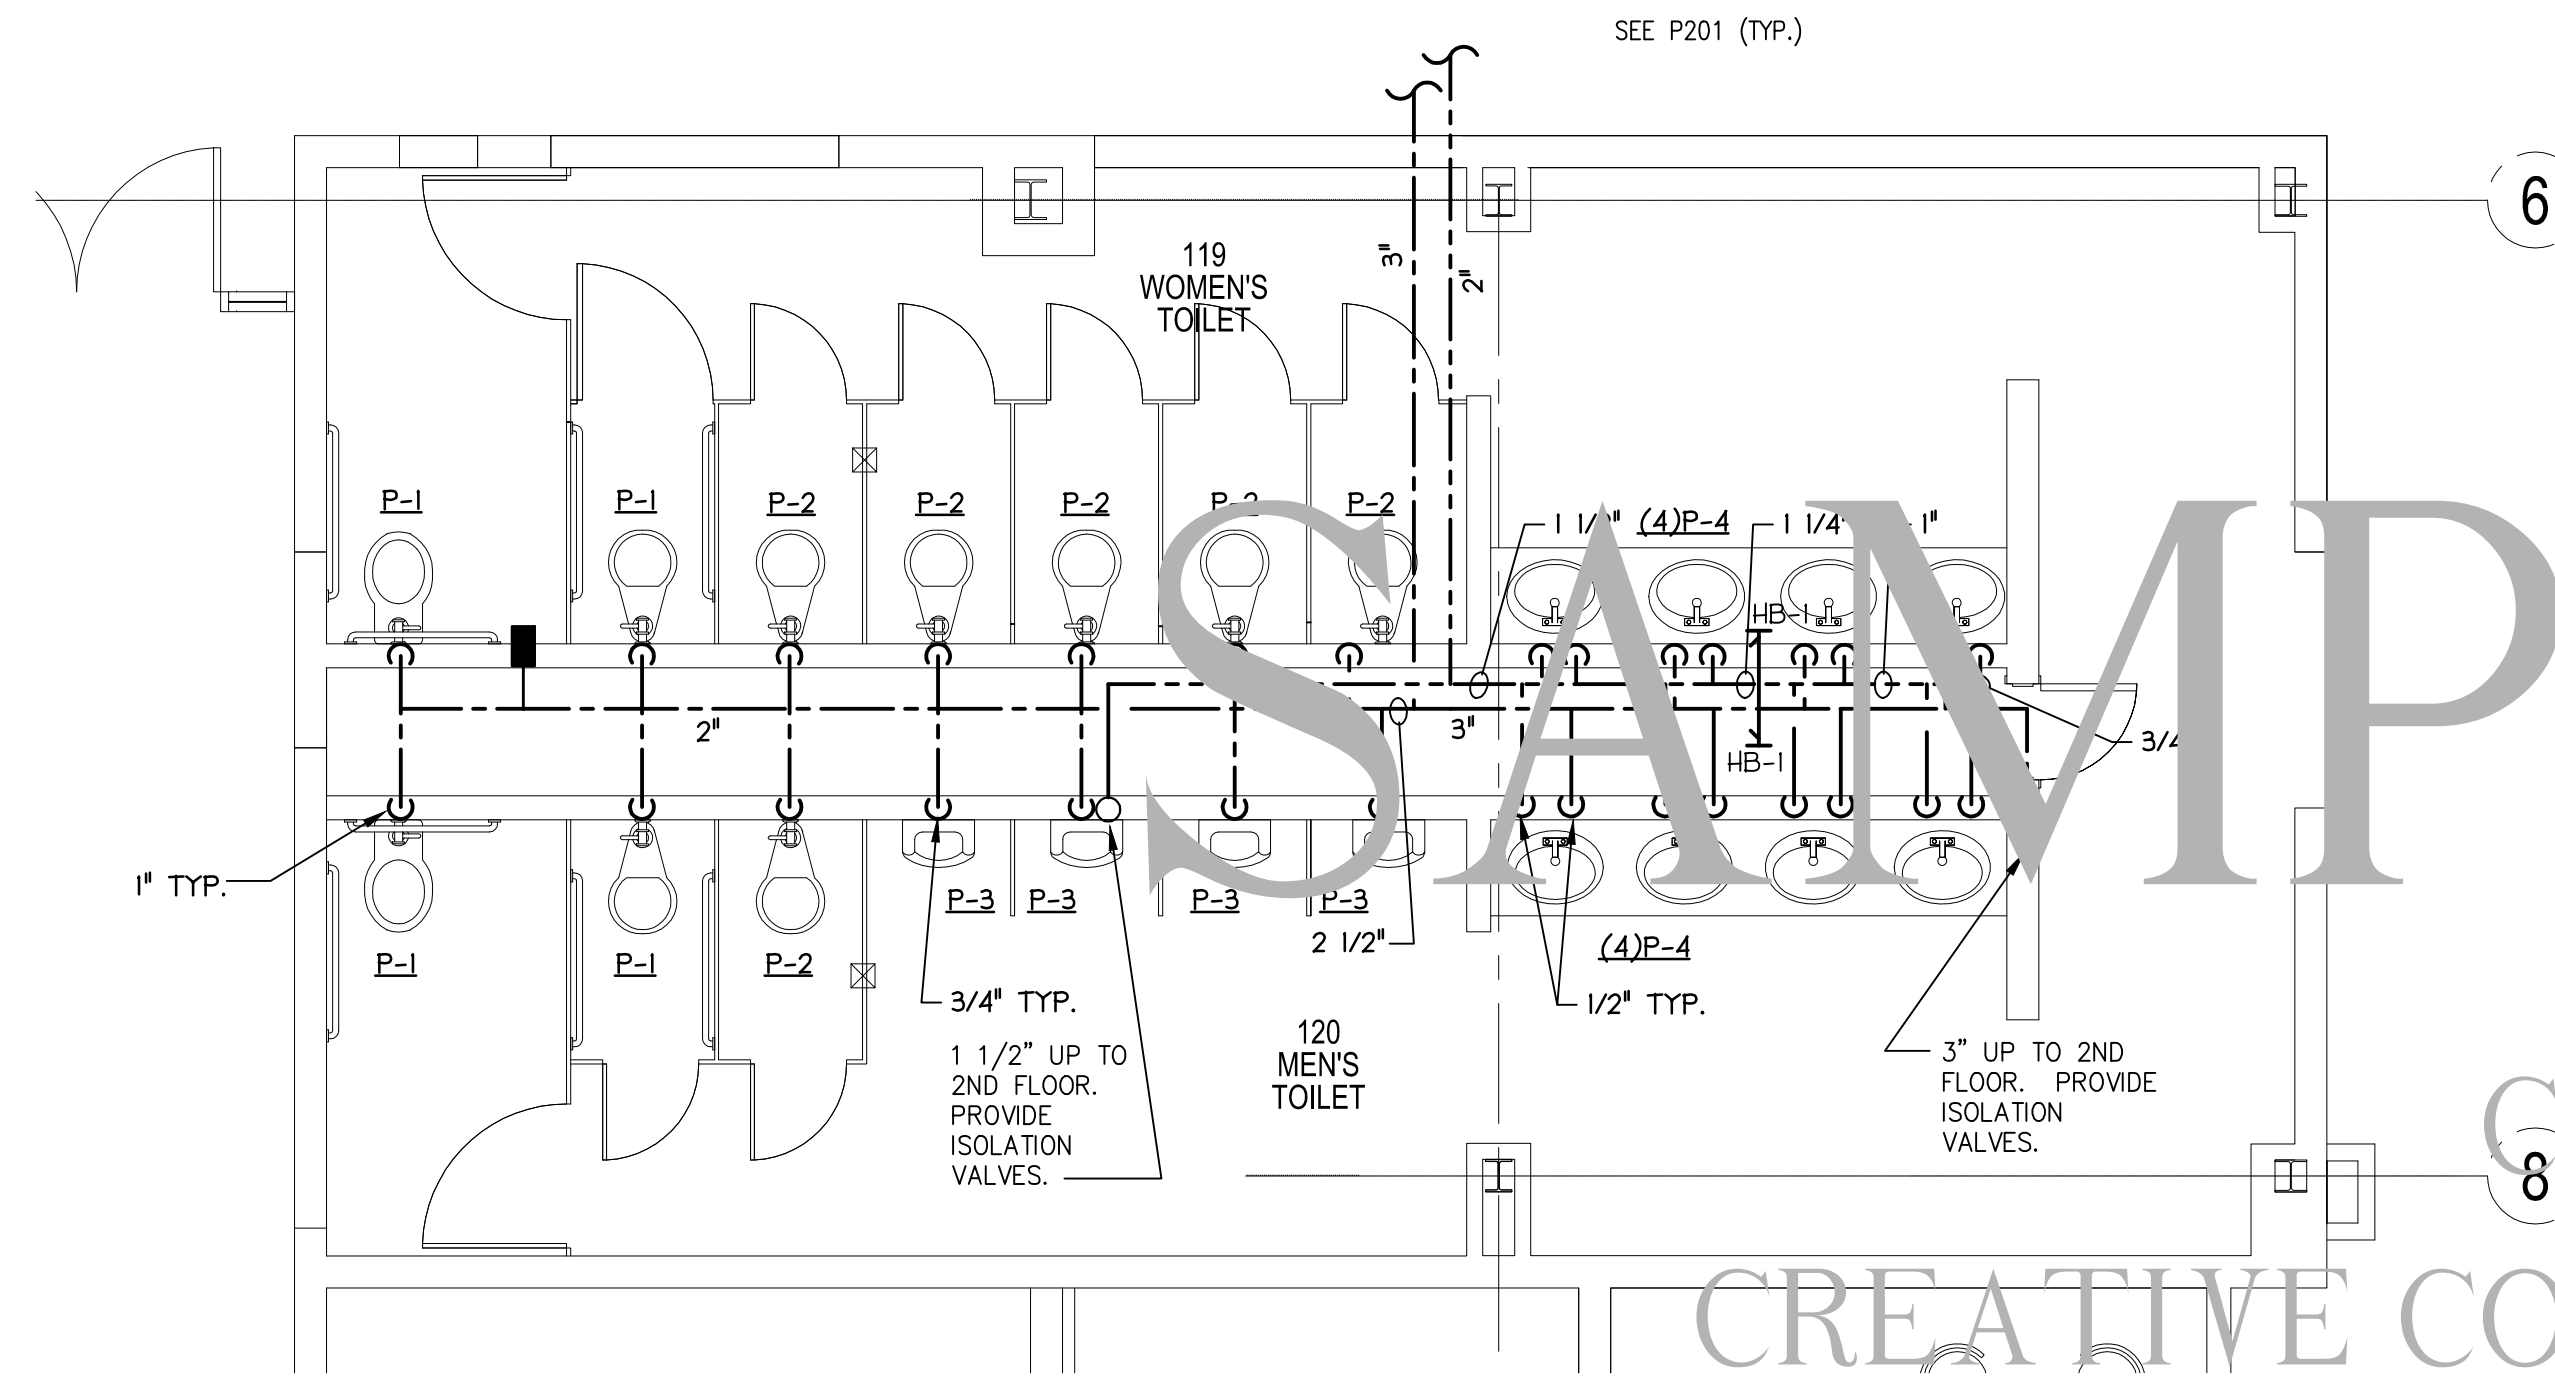


3 ENLARGED 1ST FLOOR DOMESTIC WATER PLAN
 1/4" = 1'-0"

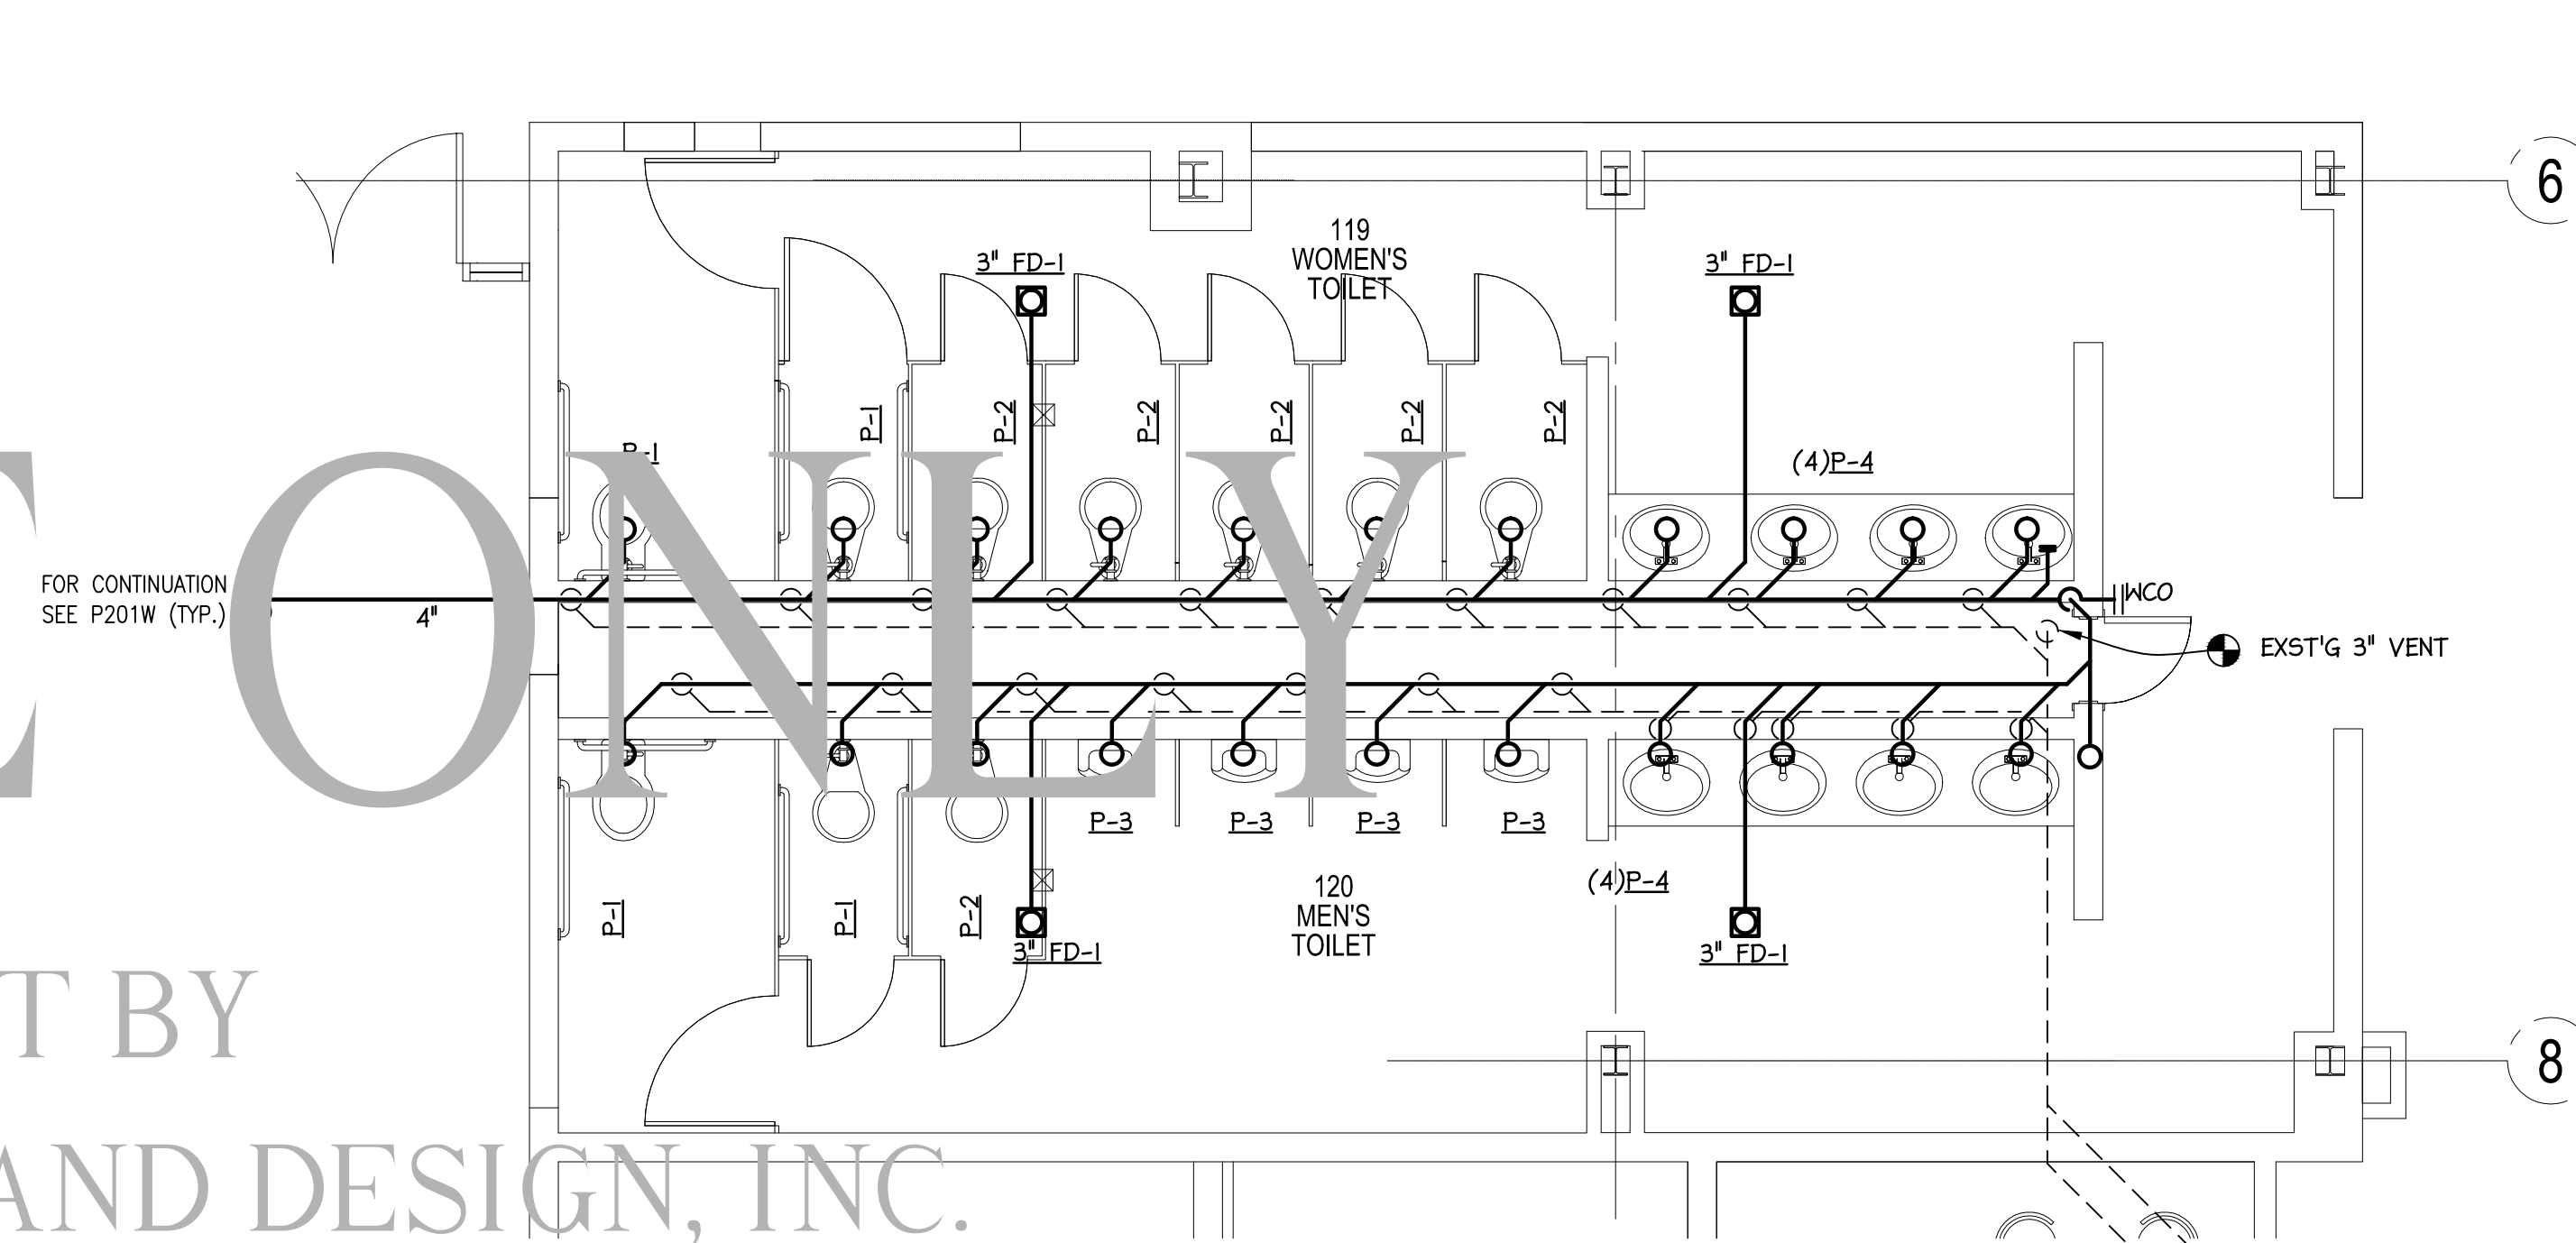

4 ENLARGED 1ST FLOOR SANITARY PLAN
 1/4" = 1'-0"

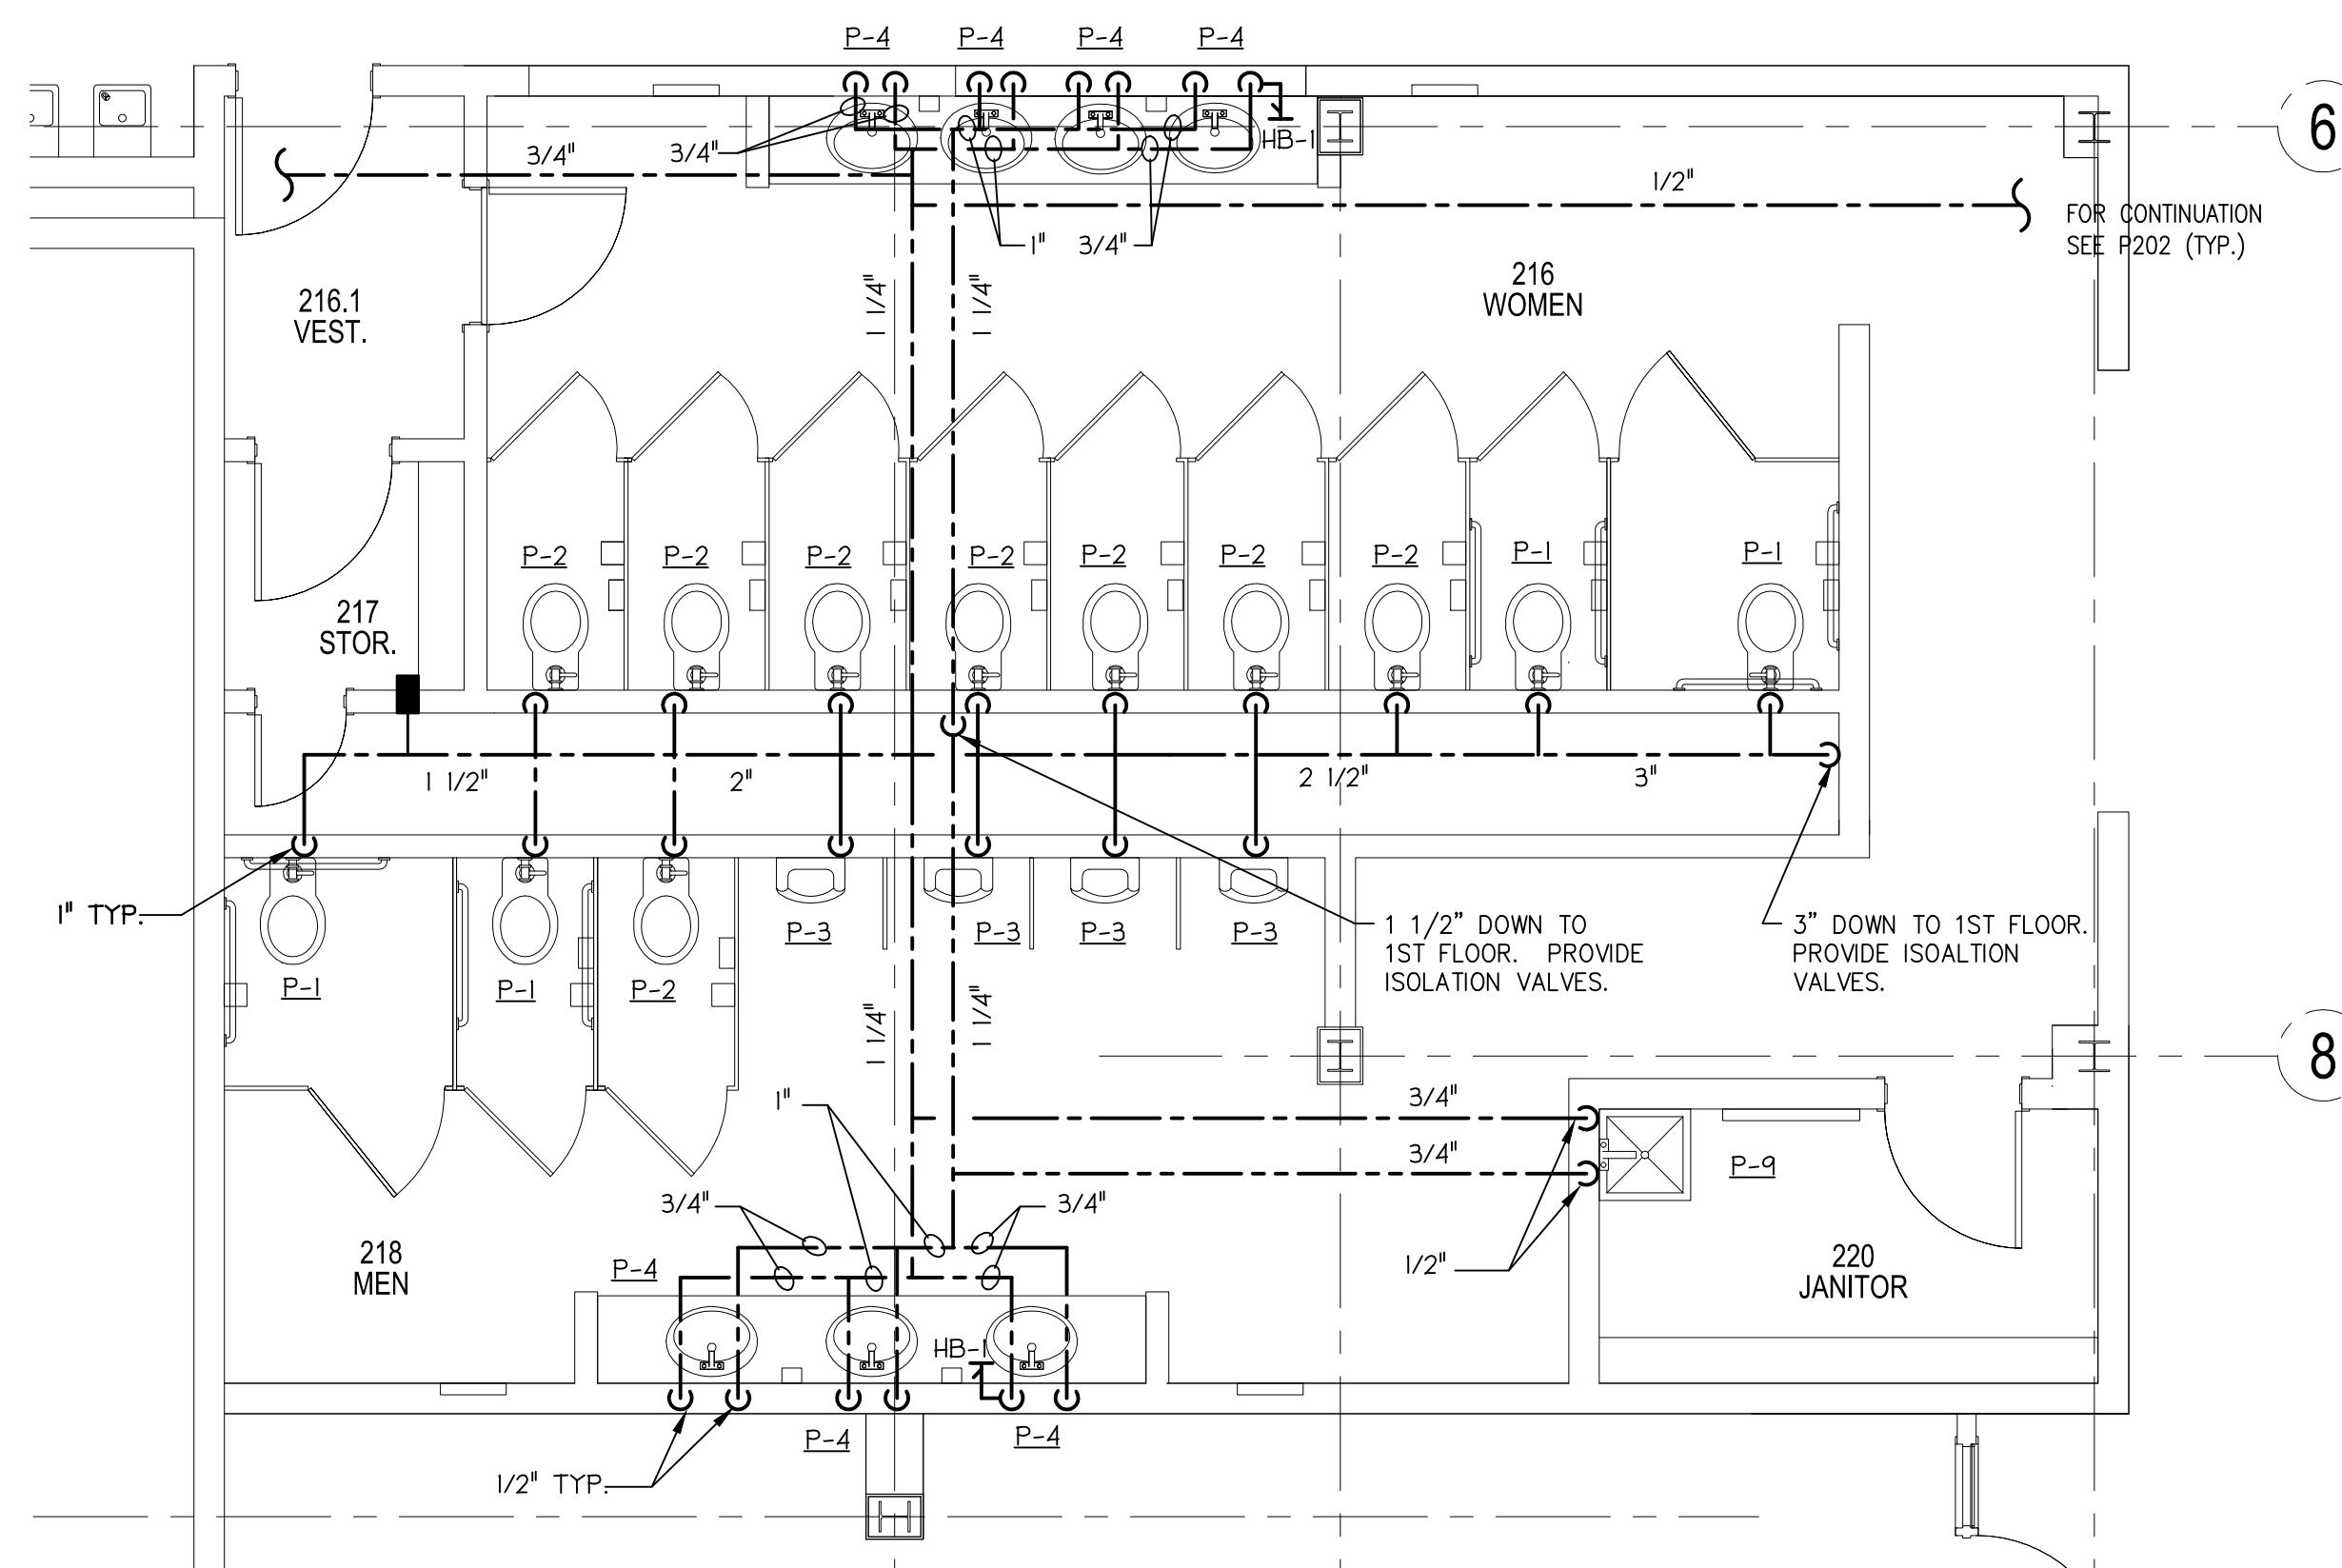

5 ENLARGED 2ND FLOOR DOMESTIC WATER PLAN
 1/4" = 1'-0"

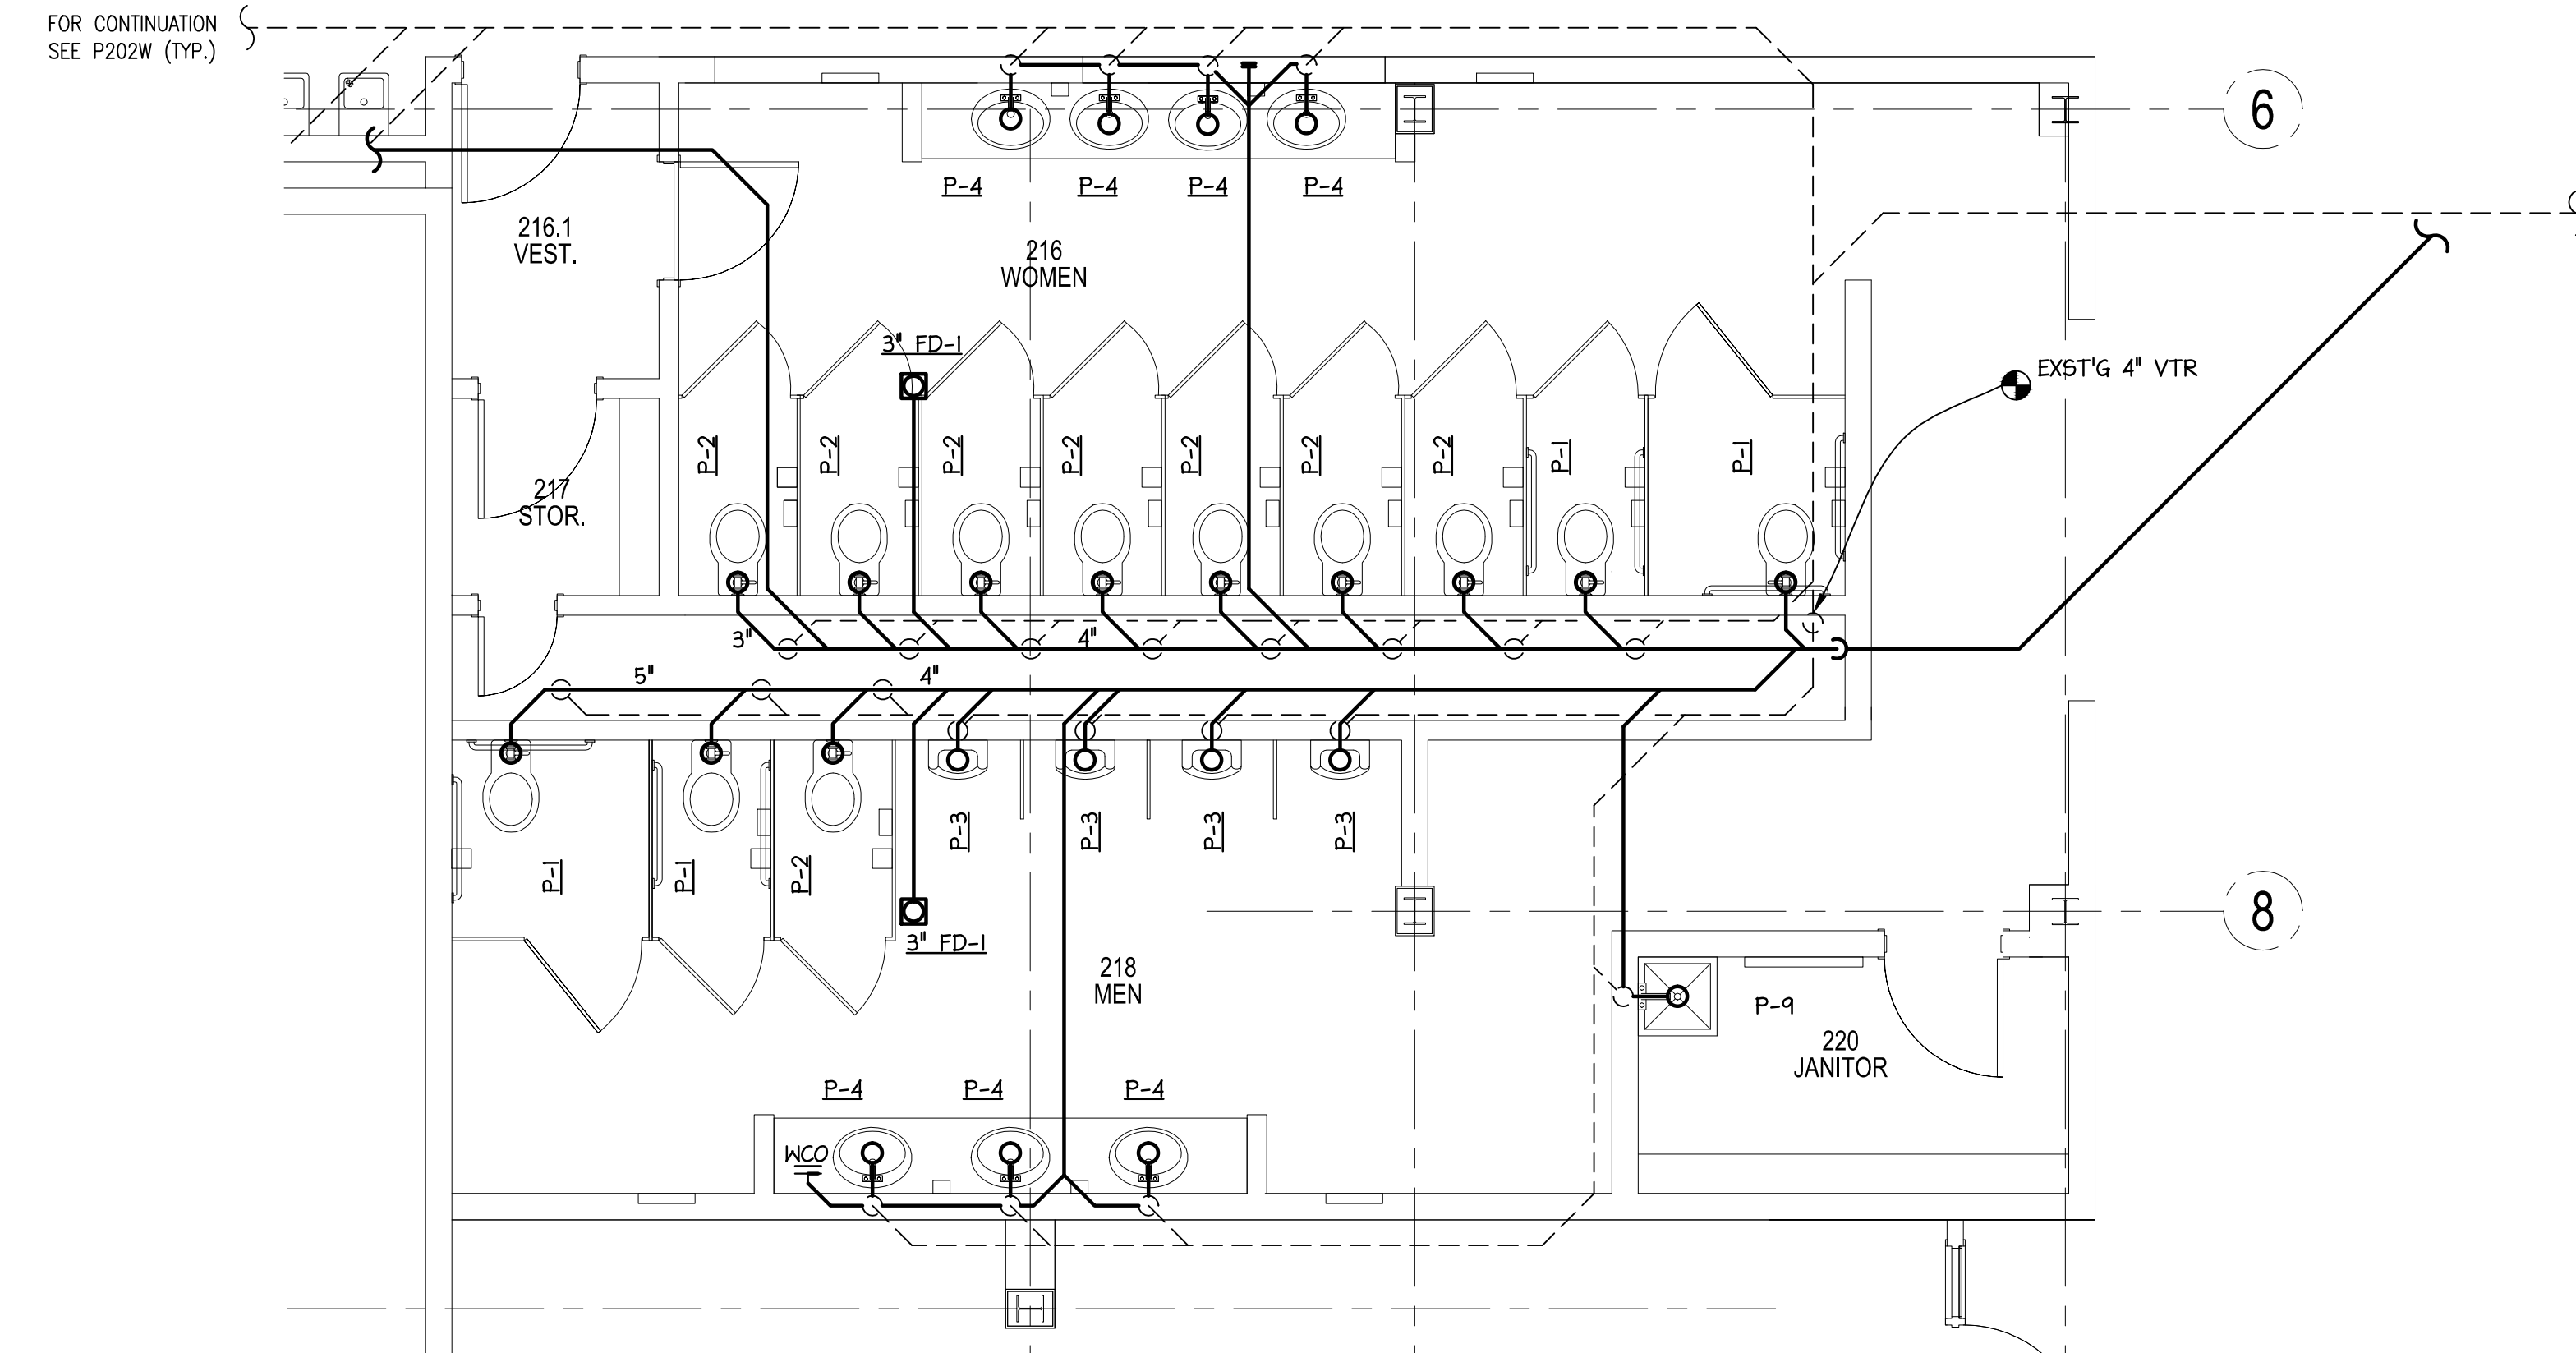

6 ENLARGED 2ND FLOOR SANITARY PLAN
 1/4" = 1'-0"

SAMPLE ONLY
 COPYRIGHT BY
 CREATIVE CONCEPTS AND DESIGN, INC.

CONSULTANT:	
SEALS:	

DESIGN DATE:	
FINAL DATE:	
REVISION DATES:	

COLLEGE RENOVATION & EXPANSION

PROJECT NUMBER

SHEET TITLE
ENLARGED PLUMBING PLANS

SHEET NUMBER

P300