


PRELIMINARY
COORDINATION ONLY
NOT FOR CONSTRUCTION

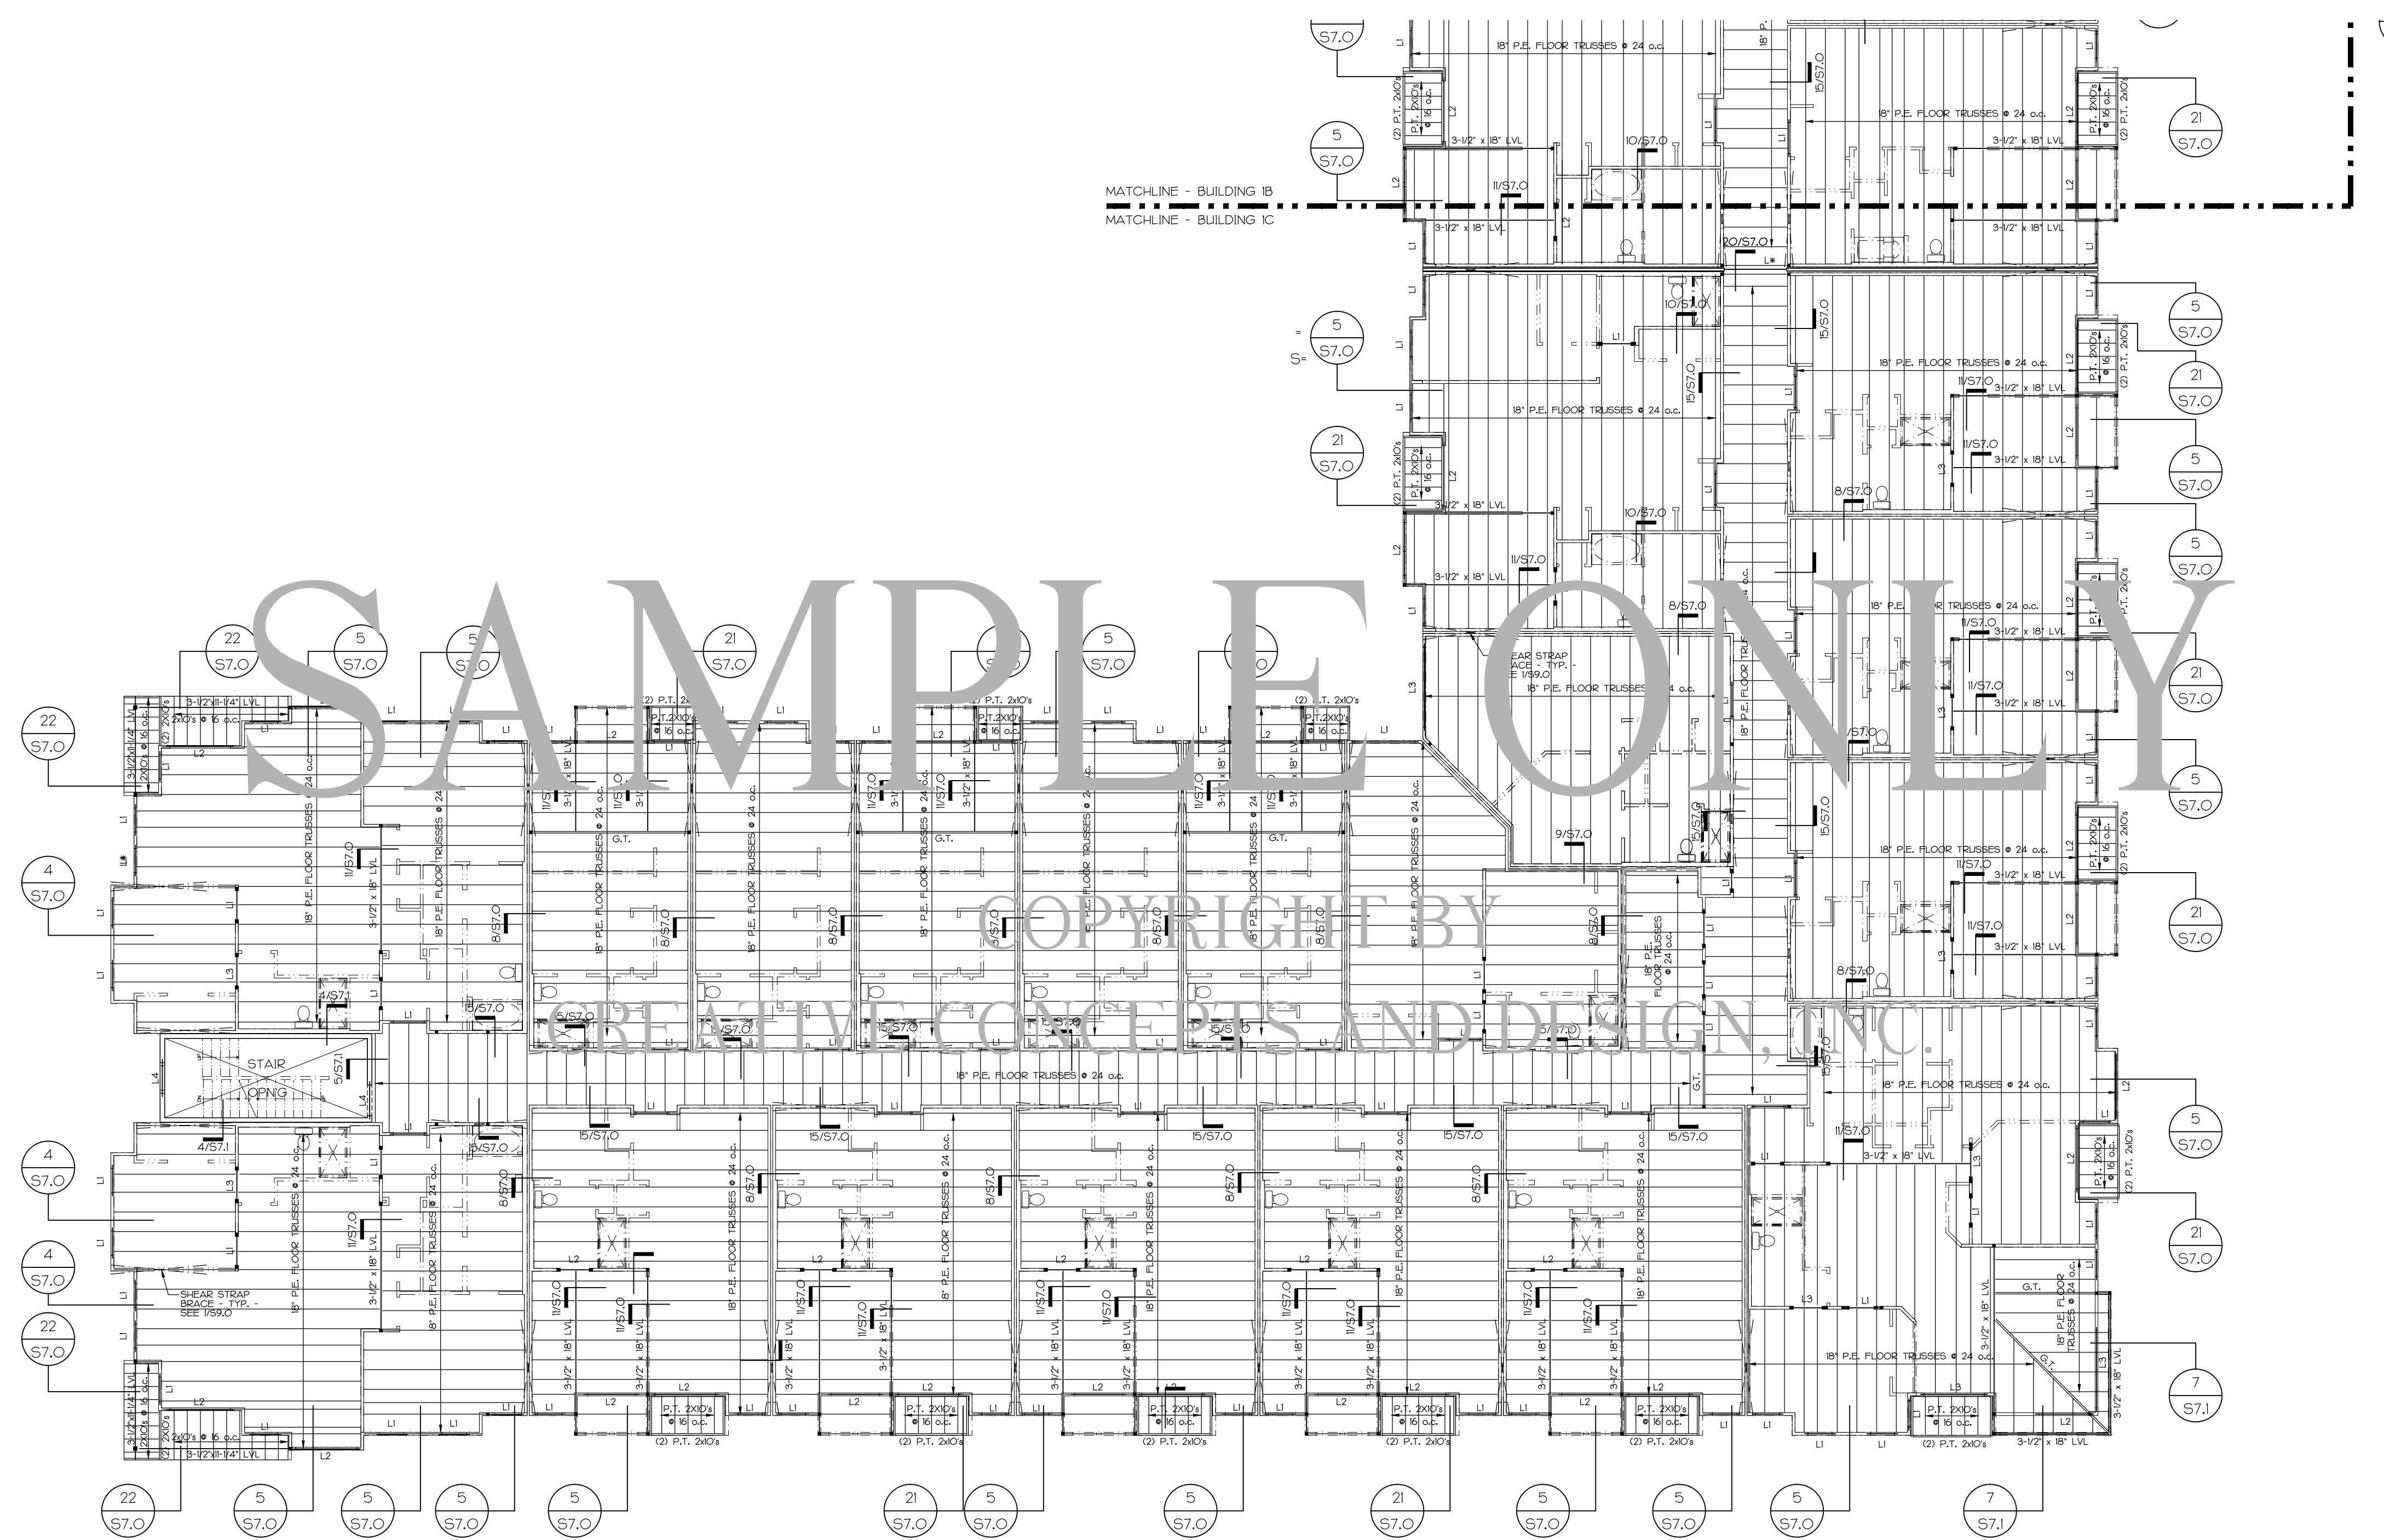

SECOND FLOOR FRAMING SHEET NOTES:
 TRUSS BEARING ELEVATION IS 4'-0 1/4" ABOVE FIRST FLOOR FINISHED FLOOR ELEVATION (FFE) (WHICH VARIES) UNLESS OTHERWISE NOTED AS 1'-0".
 SECOND FLOOR FFE IS 4'-0 1/4" ABOVE FIRST FLOOR FFE UNLESS OTHERWISE NOTED AS 1'-0".
 FLOOR CONSTRUCTION:
 3/4" CONCRETE ON 3/4" T&G PLYWOOD SUB-FLOOR ON 18" PRE-ENGINEERED OPEN WEB WOOD FLOOR TRUSSES AT 24" o.c.
 FFE — INDICATES FINISHED FLOOR ELEVATION
 FFFE — INDICATES REFERENCED FINISHED FLOOR ELEVATION
 T&G — INDICATES TOP OF T&G
 EOS — INDICATES EDGE OF SLAB
 EOB — INDICATES EDGE OF BECK
 FOB — INDICATES FACE OF BUILDING
 AFF — INDICATES ABOVE FINISHED FLOOR
 F. V. — INDICATES FIELD VERIFY
 I — INDICATES INTER. SEE SCHEDULE SHEET S10
 — INDICATES GANG OF 2 STUDS - SEE DETAILS 4/510
 — INDICATES STRAP BRACED SHEAR WALL - SEE 15/510
 IN THE CASE OF A DOUBLE WALL, BOTH WALLS SHALL HAVE STRAP BRACING INSTALLED.

ALL SECOND FLOOR LOAD BEARING WALLS SHALL BE CONSTRUCTED USING SINGLE (1) 24" x 16" o.c.

NOTE:
 CCC SHALL BE RESPONSIBLE FOR COORDINATING LOCATION OF FLOOR TRUSSES IN RELATION TO ALL MECHANICAL UNITS & DUCTWORK, PLUMBING FIXTURES & PIPING, ETC. PRIOR TO FRAMING.

DIMENSIONING NOTE:
 DIMENSIONS SHOWN ARE TO OUTSIDE FACE OF STUD OR EDGE OF SLAB. SEE ARCHITECTURAL DRAWINGS FOR MASONRY VENEER SIZE, TYPE, LOCATION AND DIMENSIONS. COORDINATE ALL DIMENSIONS SHOWN WITH LATEST ARCHITECTURAL FLOOR PLANS, AND NOTIFY ARCHITECT OF ANY CONFLICTS.

WALLS IN THE CORRIDORS (ON BOTH SIDES OF THE WALL) TO BE 3/8" x 48" INTERIOR SHEET ROCK ON 2x4/2x6 WALL STUDS (SPACED AS NOTED ON PLANS) WITH 6x COOLER NAILS @ 24" o.c. ALL EDGES AND STUDS AT FIRST FLOOR, 24" o.c. AT UPPER FLOORS.
 INTERIOR TENANT SEPARATION WALLS BETWEEN UNITS AND CORRIDORS SHALL BE 5/8" x 48" INTERIOR SHEET ROCK ON 2x4/2x6 WALL STUDS (SPACED AS NOTED ON PLANS) WITH 6x COOLER NAILS @ 24" o.c. ALL EDGES AND STUDS AT FIRST FLOOR, 24" o.c. AT UPPER FLOORS.

SECOND FLOOR FRAMING PLAN
 3/8" = 1'-0"

HSPA# 1805
 BLDG #1 - PART 'C'
 SECOND FLOOR FRAMING

SEPTEMBER 2, 2014

S3.2