




1 BUILDING A EAST ELEVATION 1/8"=1'-0"

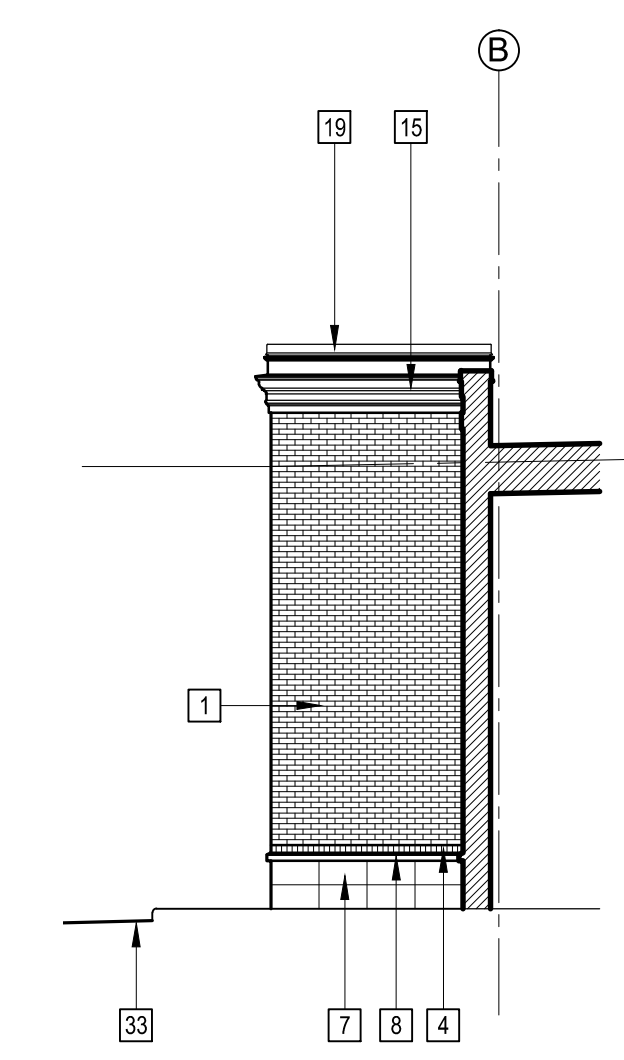


5 SPRINKLER RISER RM. BLDG A SOUTH ELEVATION 1/8"=1'-0"

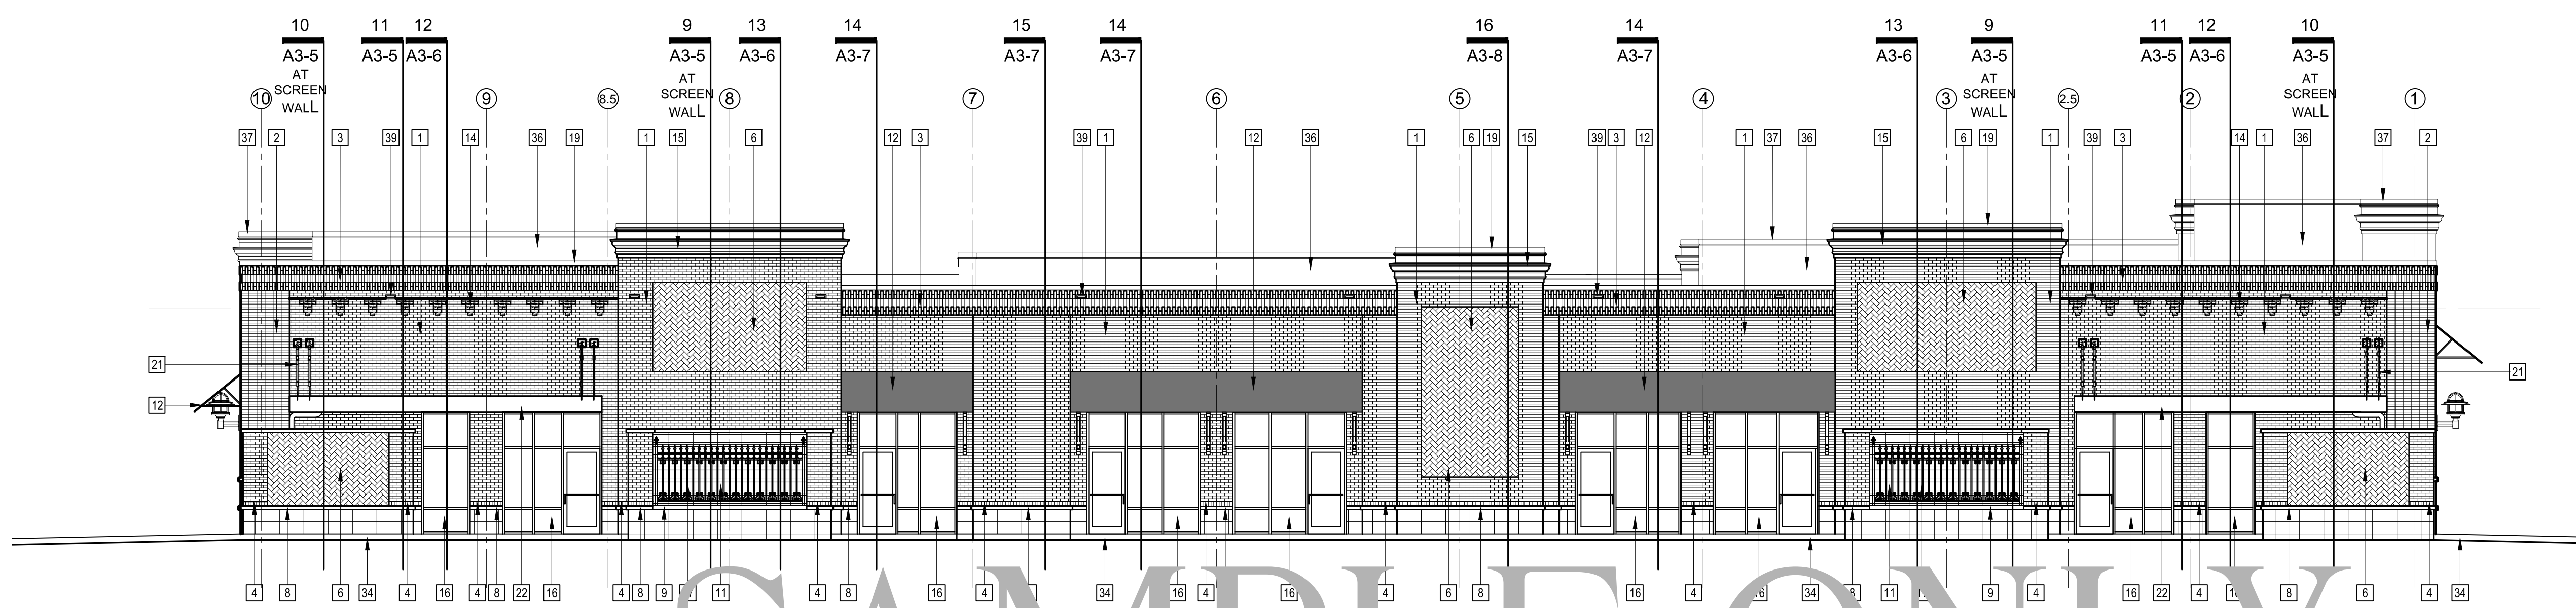


2 BUILDING A WEST ELEVATION 1/8"=1'-0"

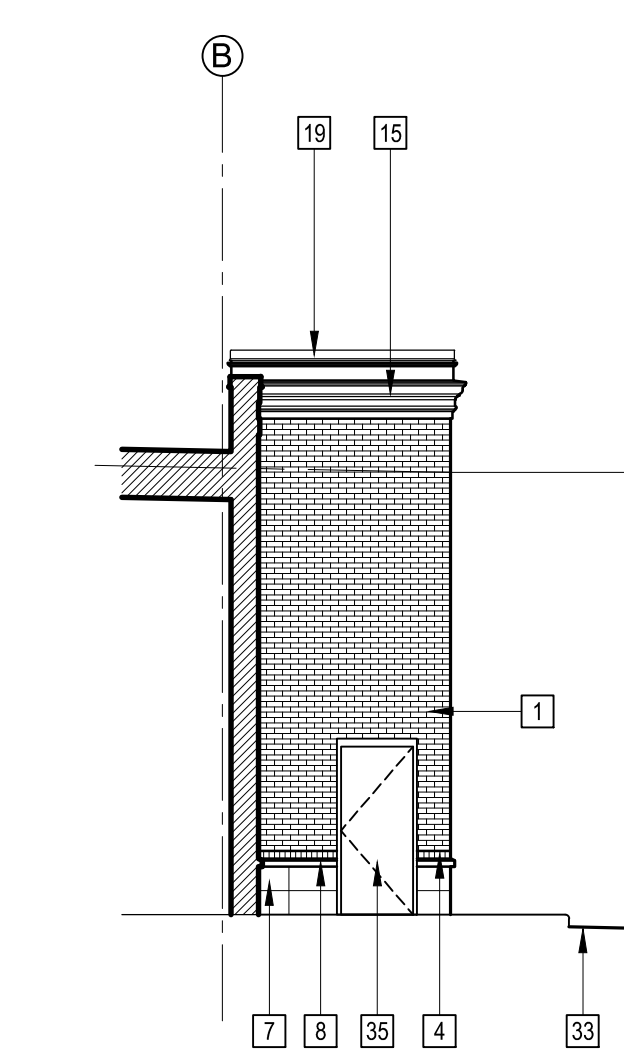


6 SPRINKLER RISER RM. BLDG A NORTH ELEVATION 1/8"=1'-0"

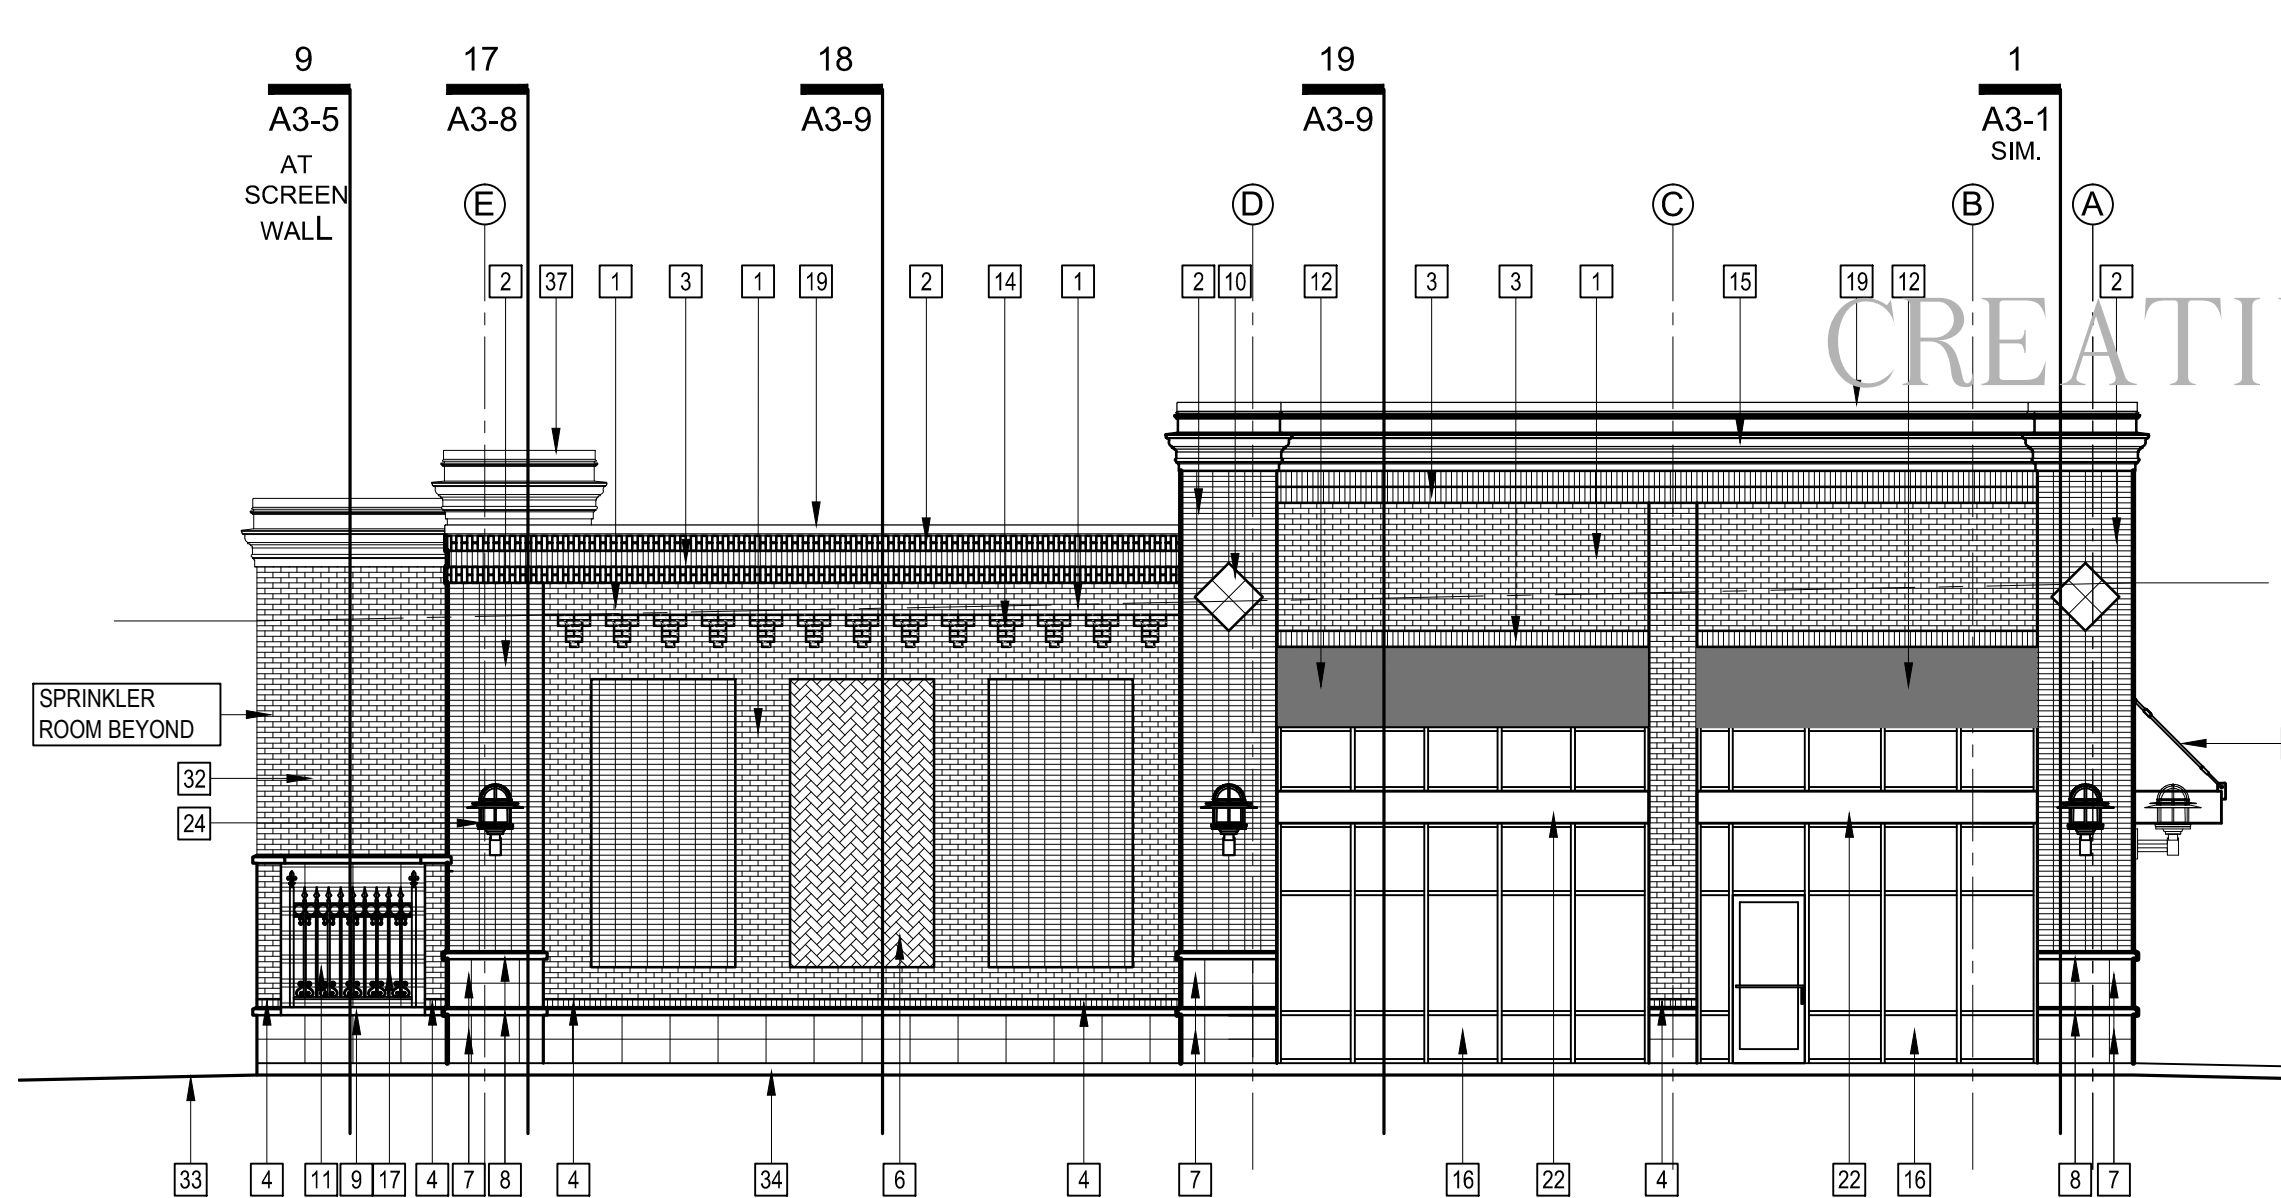

3 BUILDING A SOUTH ELEVATION 1/8"=1'-0"

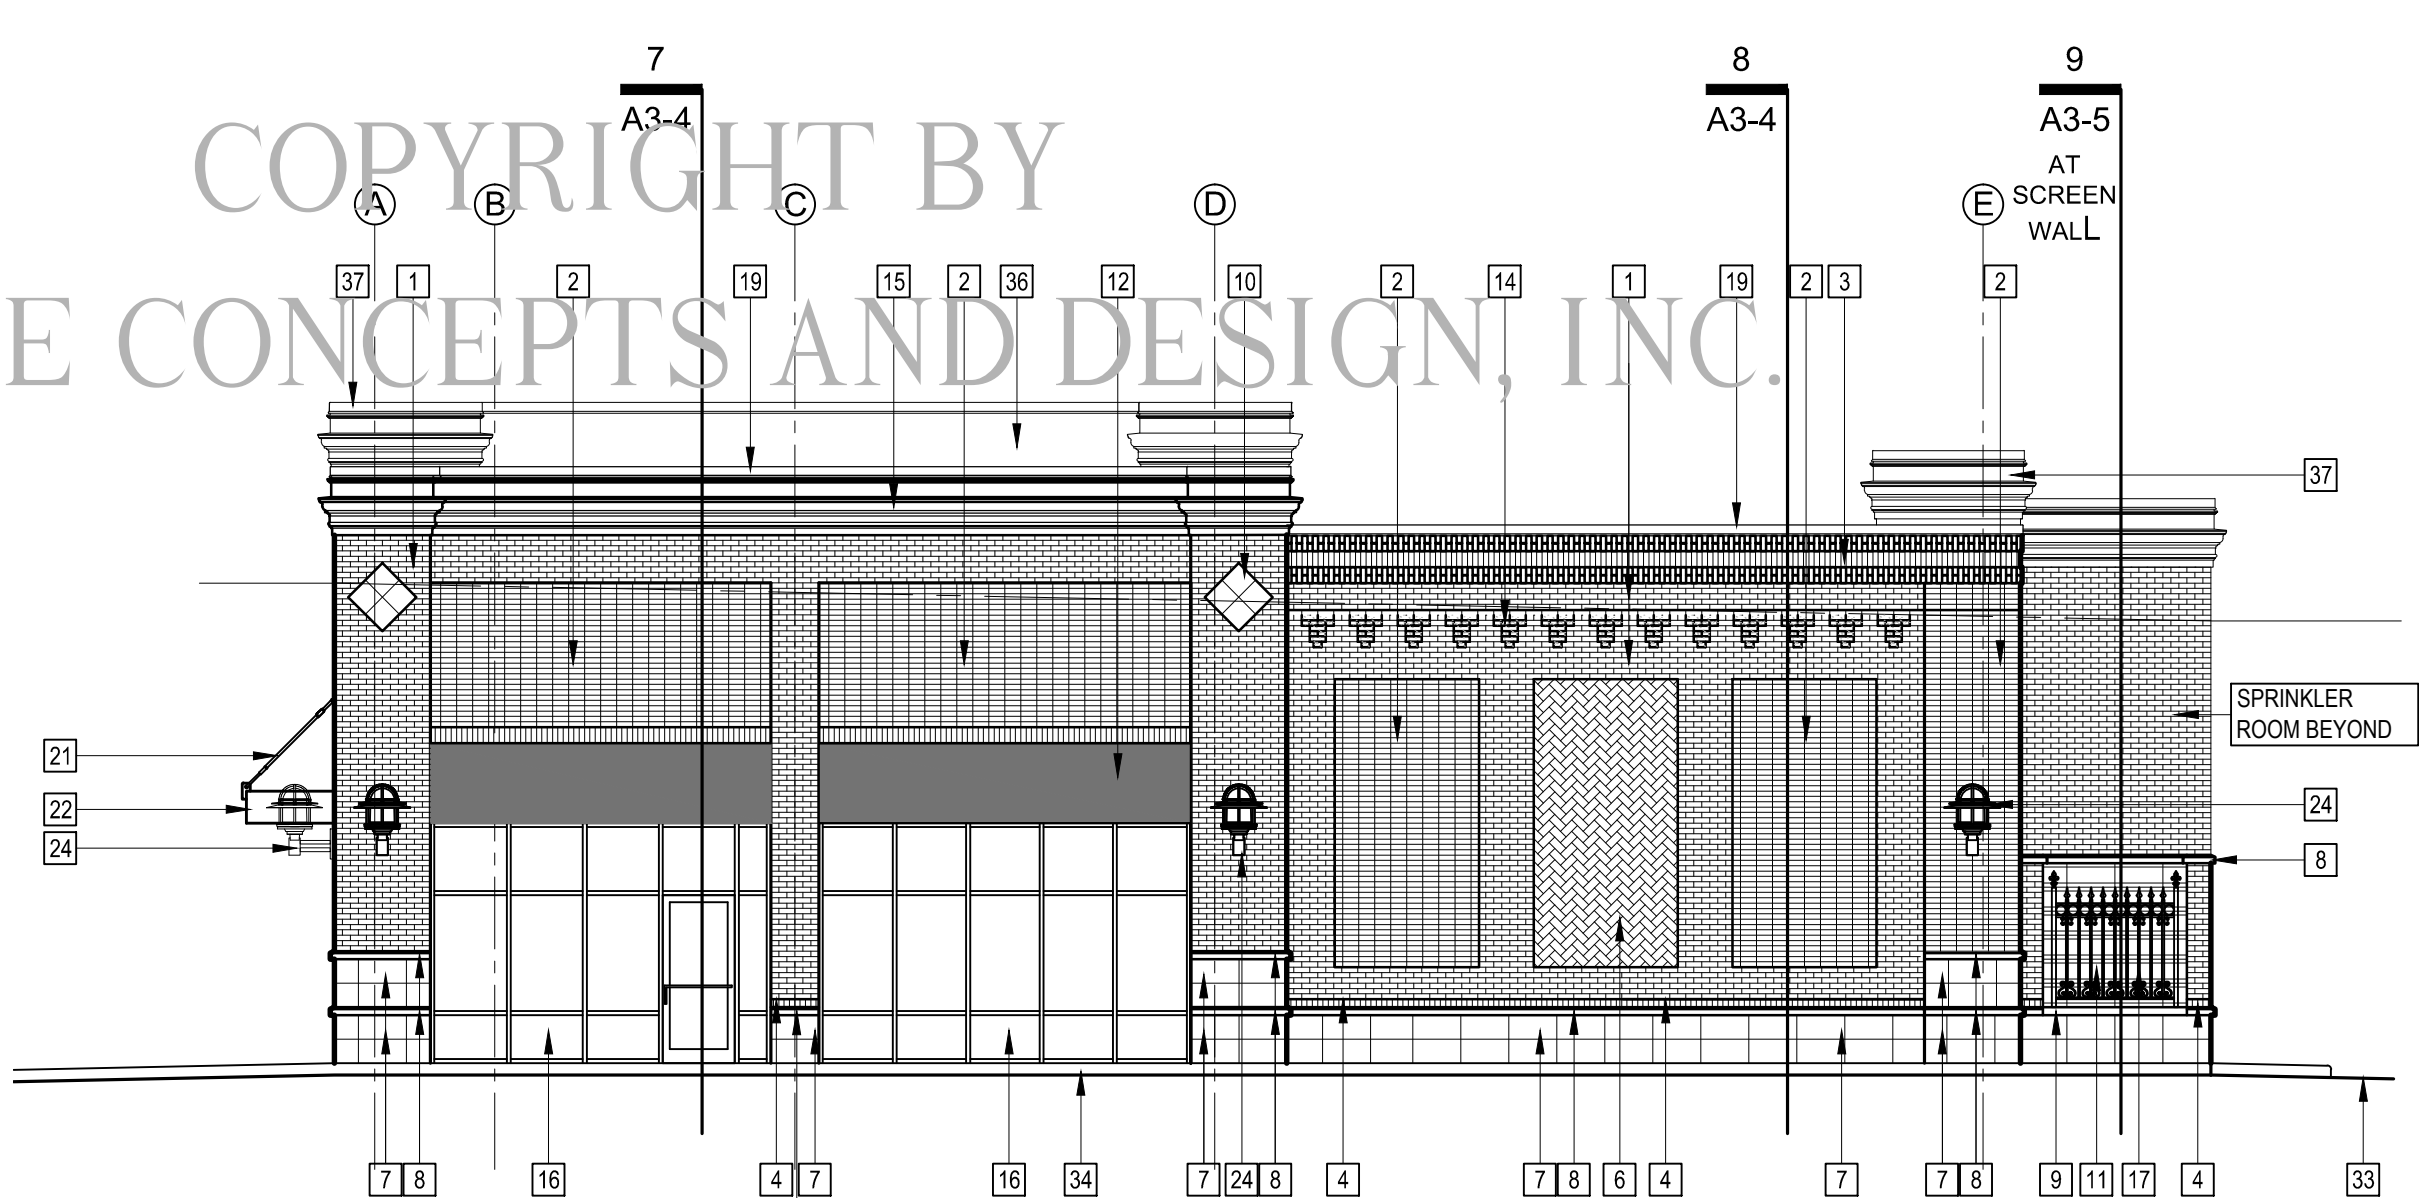

4 BUILDING A NORTH ELEVATION 1/8"=1'-0"

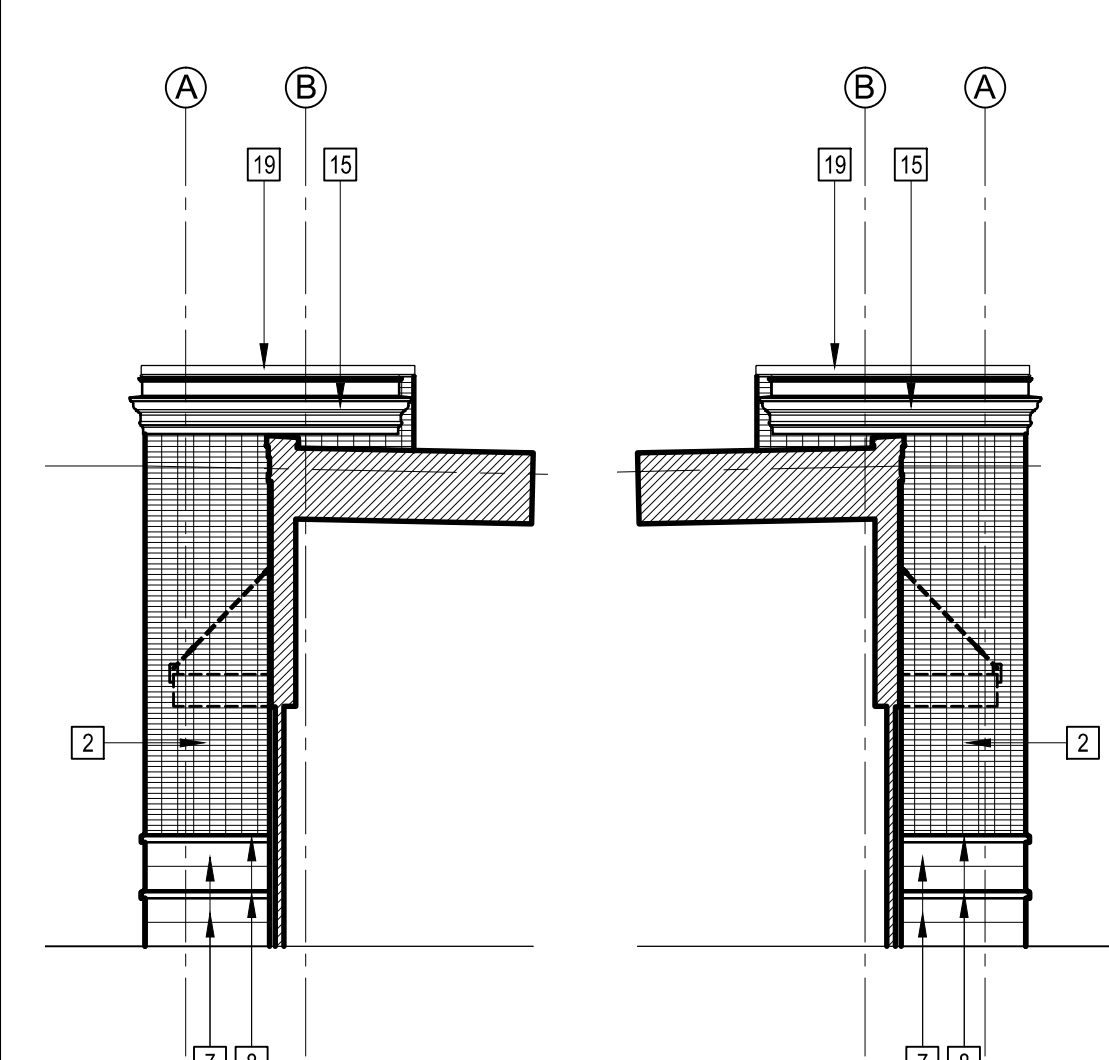

7 ELEVATIONS @ RETURNS 1/8"=1'-0"

- PRELIMINARY NOT FOR CONSTRUCTION
- ISSUED FOR BIDDING
- ISSUED FOR PERMIT
- ISSUED FOR CONSTRUCTION

Drawing Status

Owner

Project

Sheet Title

EXTERIOR ELEVATIONS, BUILDING A

Drawn By _____
 Issue Date: _____
 Drawing File Name: 1713_A2-1.1_Elevations.dwg
 Revisions:
 No. _____ Date _____
 No. _____ Date _____
 No. _____ Date _____
 No. _____ Date _____

Project Number: 17-13
 Building: _____

Sheet _____ of _____
 A2-1.1