


1 Enlarged Floor Plan Section B
1/8" = 1'-0"

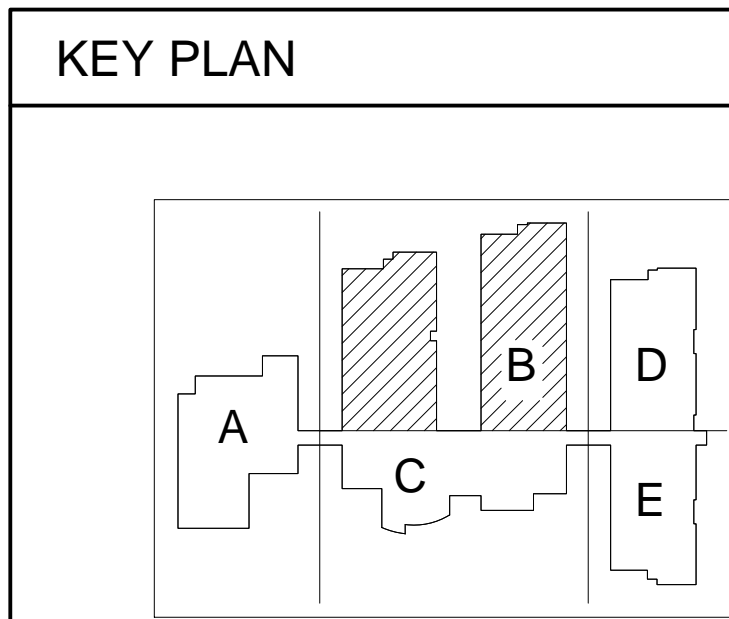

Elementary School

BID SET

REV.	DESCRIPTION	DATE

SHEET TITLE
ENLARGED HVAC PLAN SECTION B

DRAWN BY: _____ PROJ. MANAGER: _____
PROJ. NUMBER: _____
ISSUE DATE: _____
DRAWING NO. _____

M2.02